


~~RESTRICTED~~
SECURITY INFORMATION U:CLASSIFIED

Unclassified

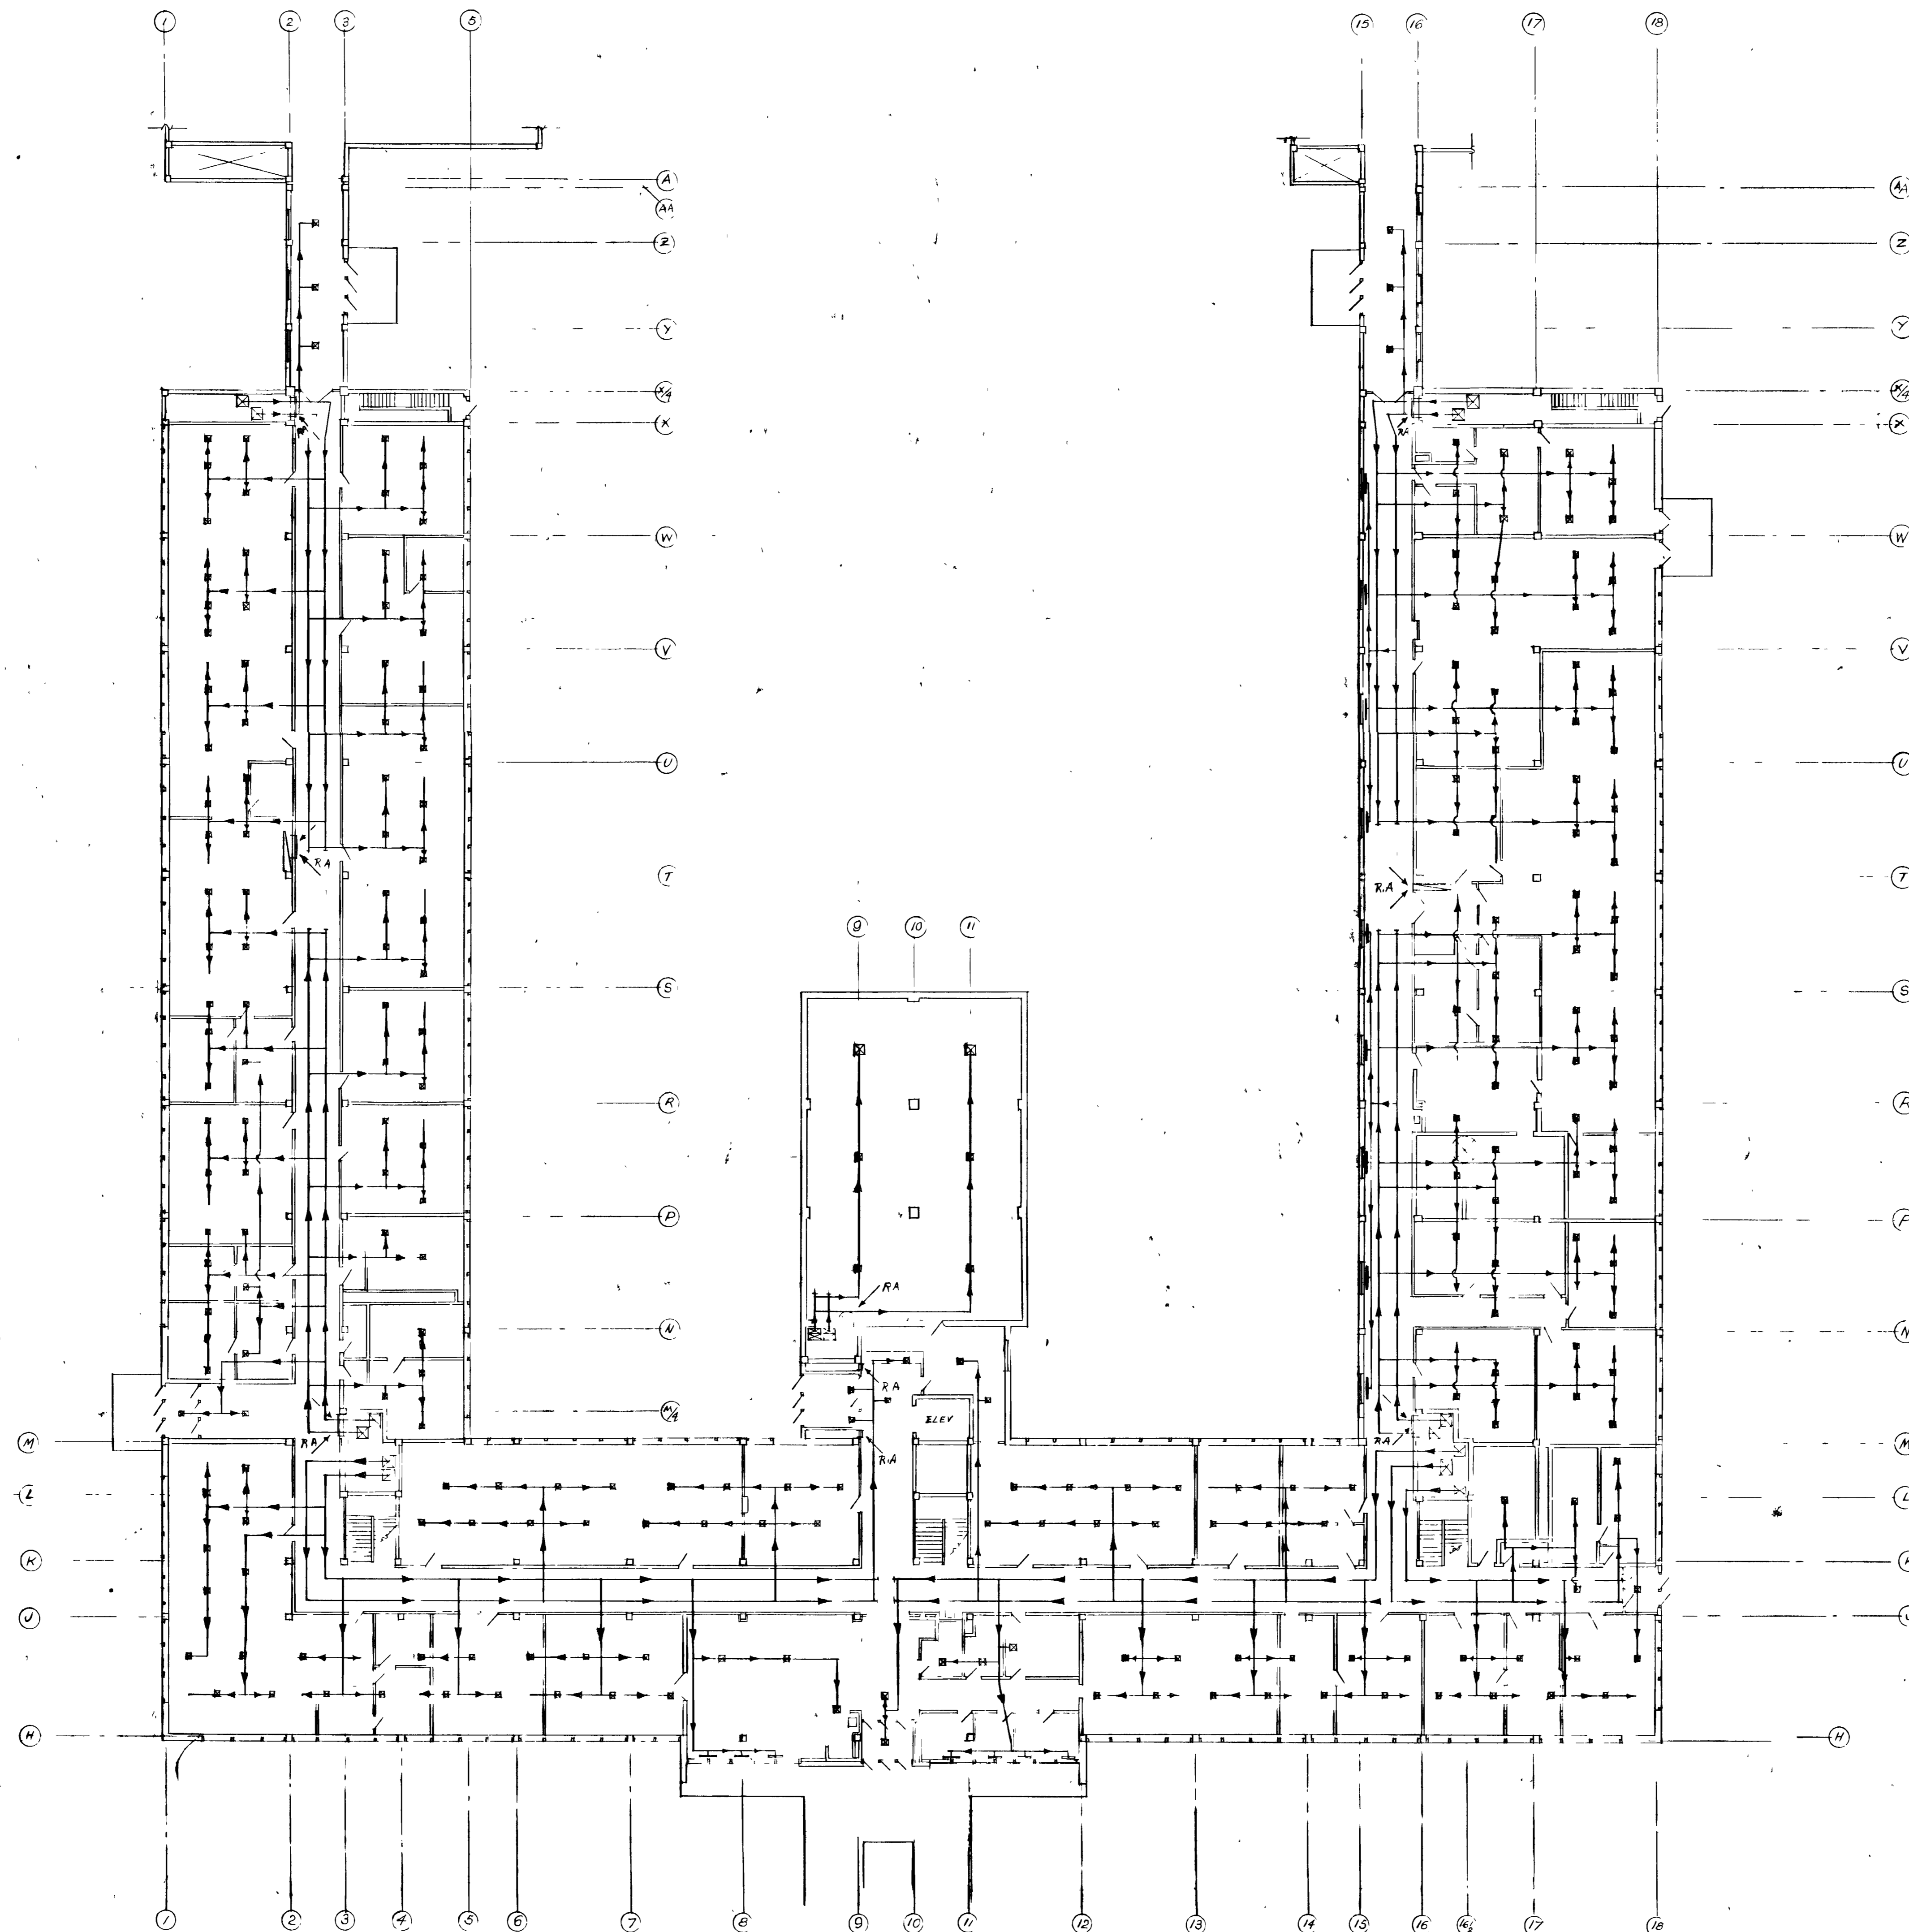


AIR FLOW DIAGRAM
(SCALE 1/4"=1'-0")

REVIEWED FOR
CLASSIFICATION
TWP 05/21/2014
Initials Date
UNCLASSIFIED

REFERENCE DRAWINGS
BI-13-M
BI-14-M
BI-15-M

Unclassified

~~RESTRICTED~~

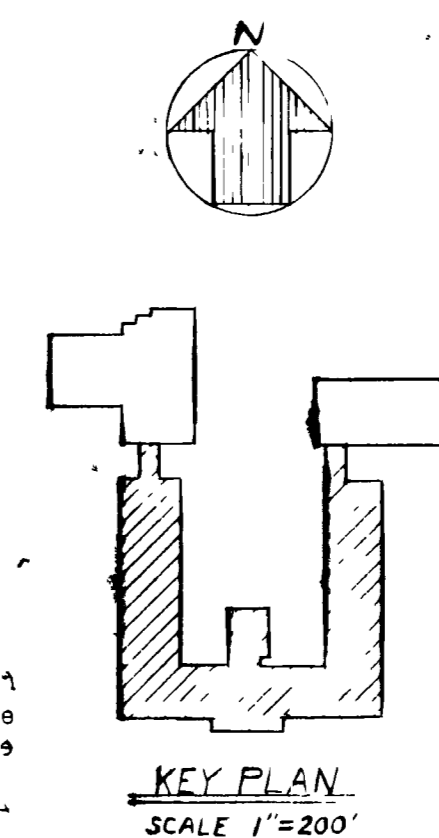

DEPARTMENT OF ENERGY DECLASSIFICATION REVIEW	
1ST REVIEWER: [Signature]	DETERMINATION: [Signature]
2ND REVIEWER: [Signature]	DATE: [Signature]
APPROVED BY: [Signature]	DATE: [Signature]

BT Images, Inc
00000501

Unclassified
CLASSIFICATION CHANGED TO
By Authority of [Signature] DATE [Signature]
[Signature] DATE [Signature]
[Signature] DATE [Signature]

~~RESTRICTED~~
DATE [Signature]

UNCLASSIFIED

UNITED STATES ATOMIC ENERGY COMMISSION			
SMITH, HINCHMAN & GRYLLS, INC ARCHITECTS & ENGINEERS DETROIT 26, MICHIGAN			
DRAWING TITLE AIR CONDITIONING LAYOUT FIRST FLOOR PLAN			
DRAWN BY: [Signature]	CHECKED BY: [Signature]	DATE: [Signature]	DATE: [Signature]
IN CHARGE: [Signature]	DATE: [Signature]	DATE: [Signature]	DATE: [Signature]
PROJECT: C-PLANT	ADMINISTRATION: C-100	SHEET: 8768	BI-1-M

~~RESTRICTED~~