




Unclassified

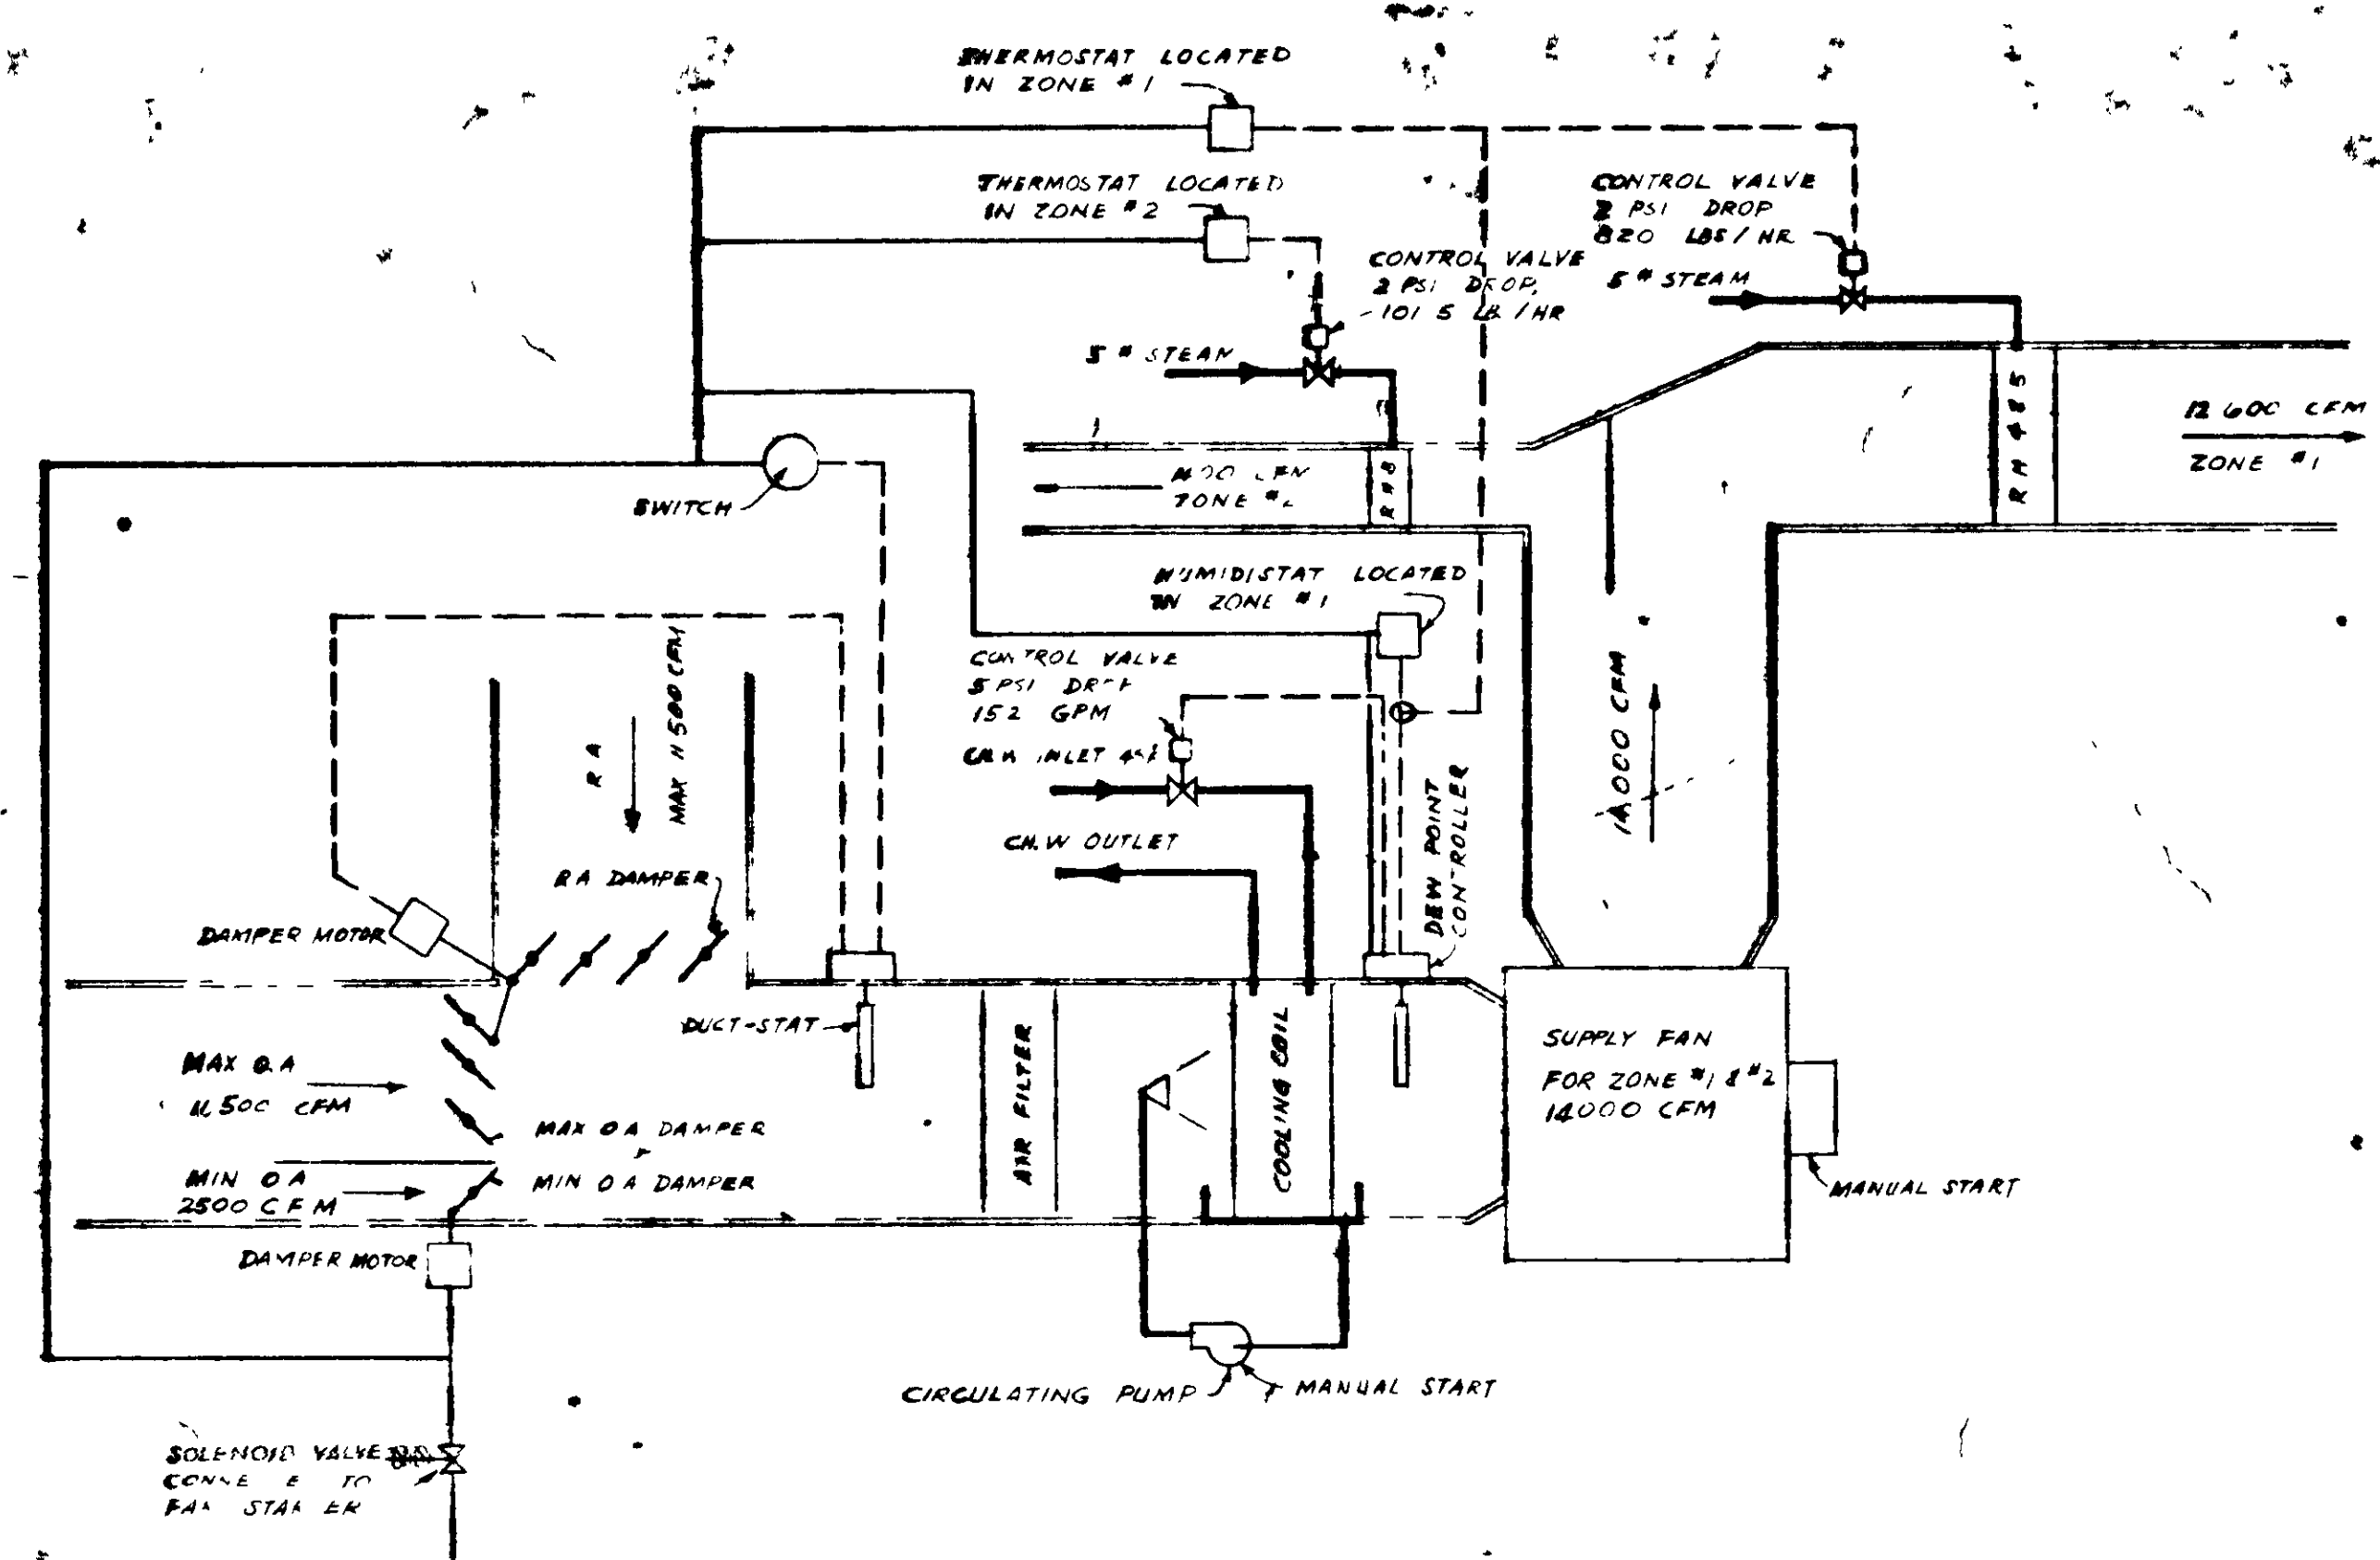


AIR CONDITIONING UNIT CONTROL DIAGRAM FOR ZONE #1 & #2
NO SCALE

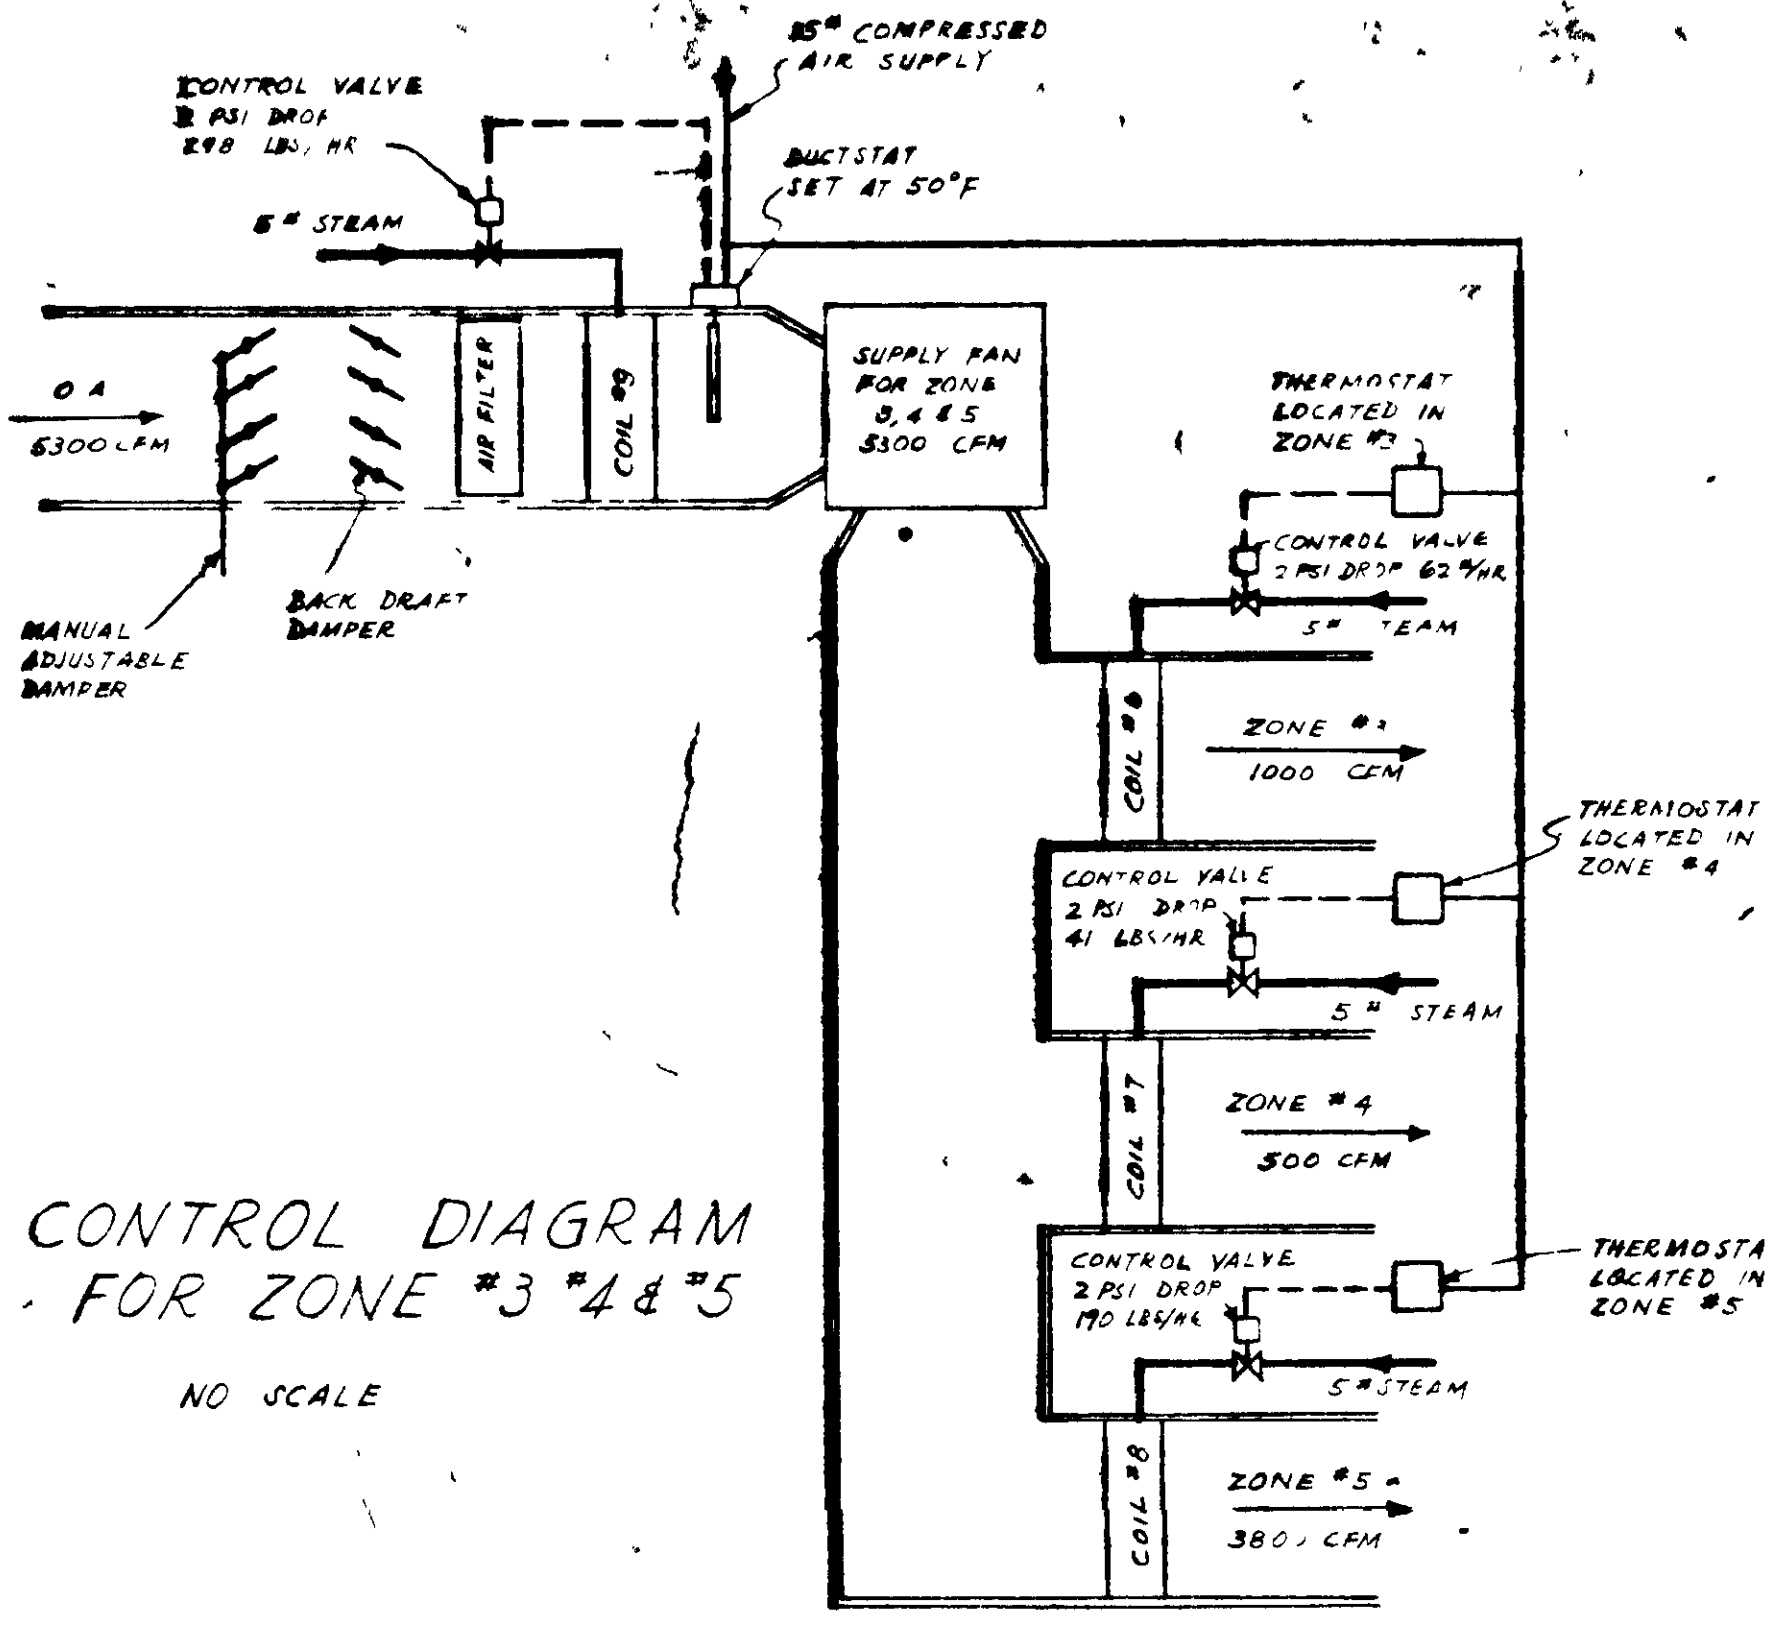


CONTROL DIAGRAM FOR ZONE #3, #4 & #5
NO SCALE

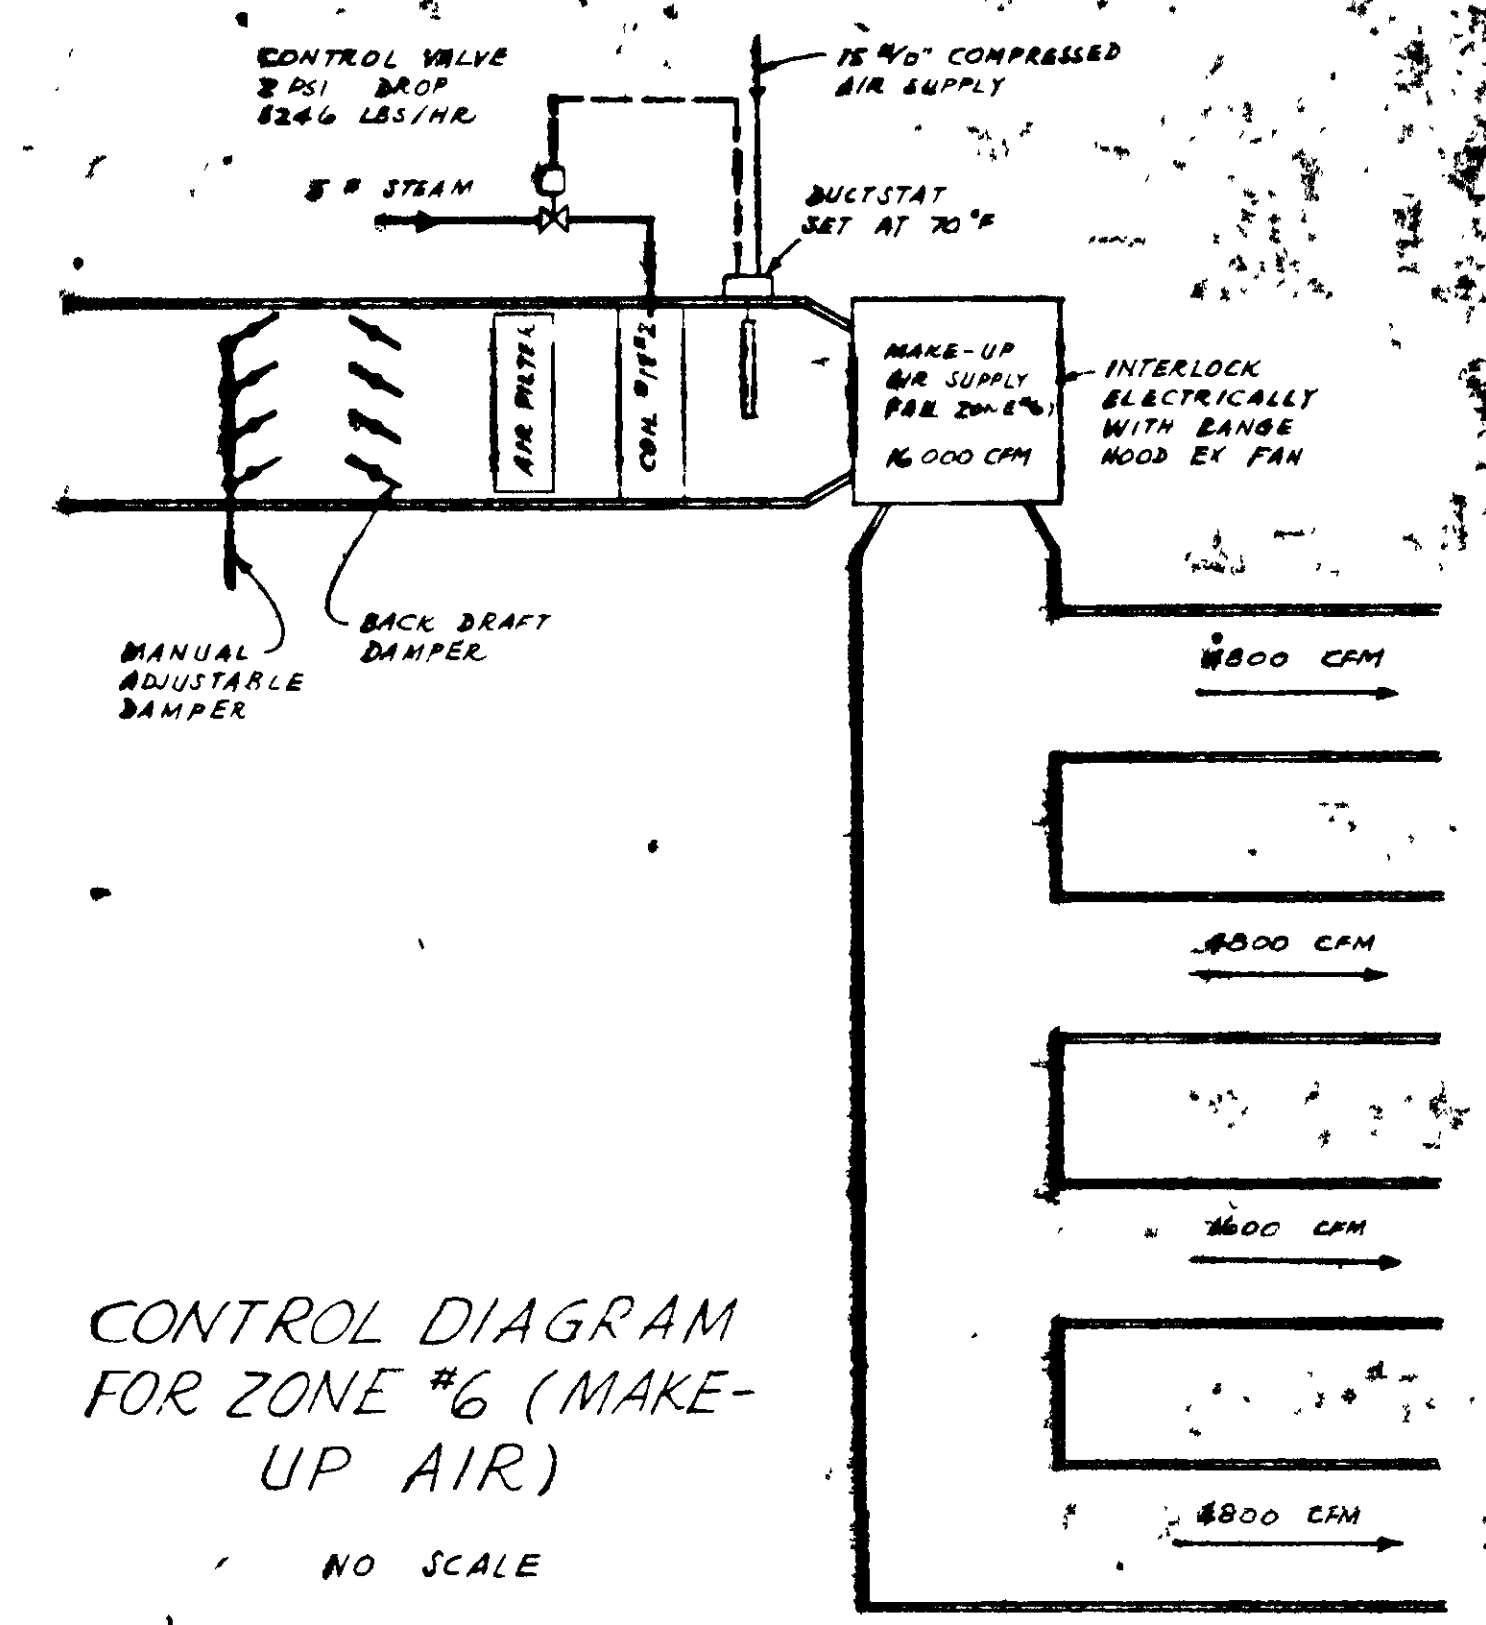


CONTROL DIAGRAM FOR ZONE #6 (MAKE-UP AIR)
NO SCALE

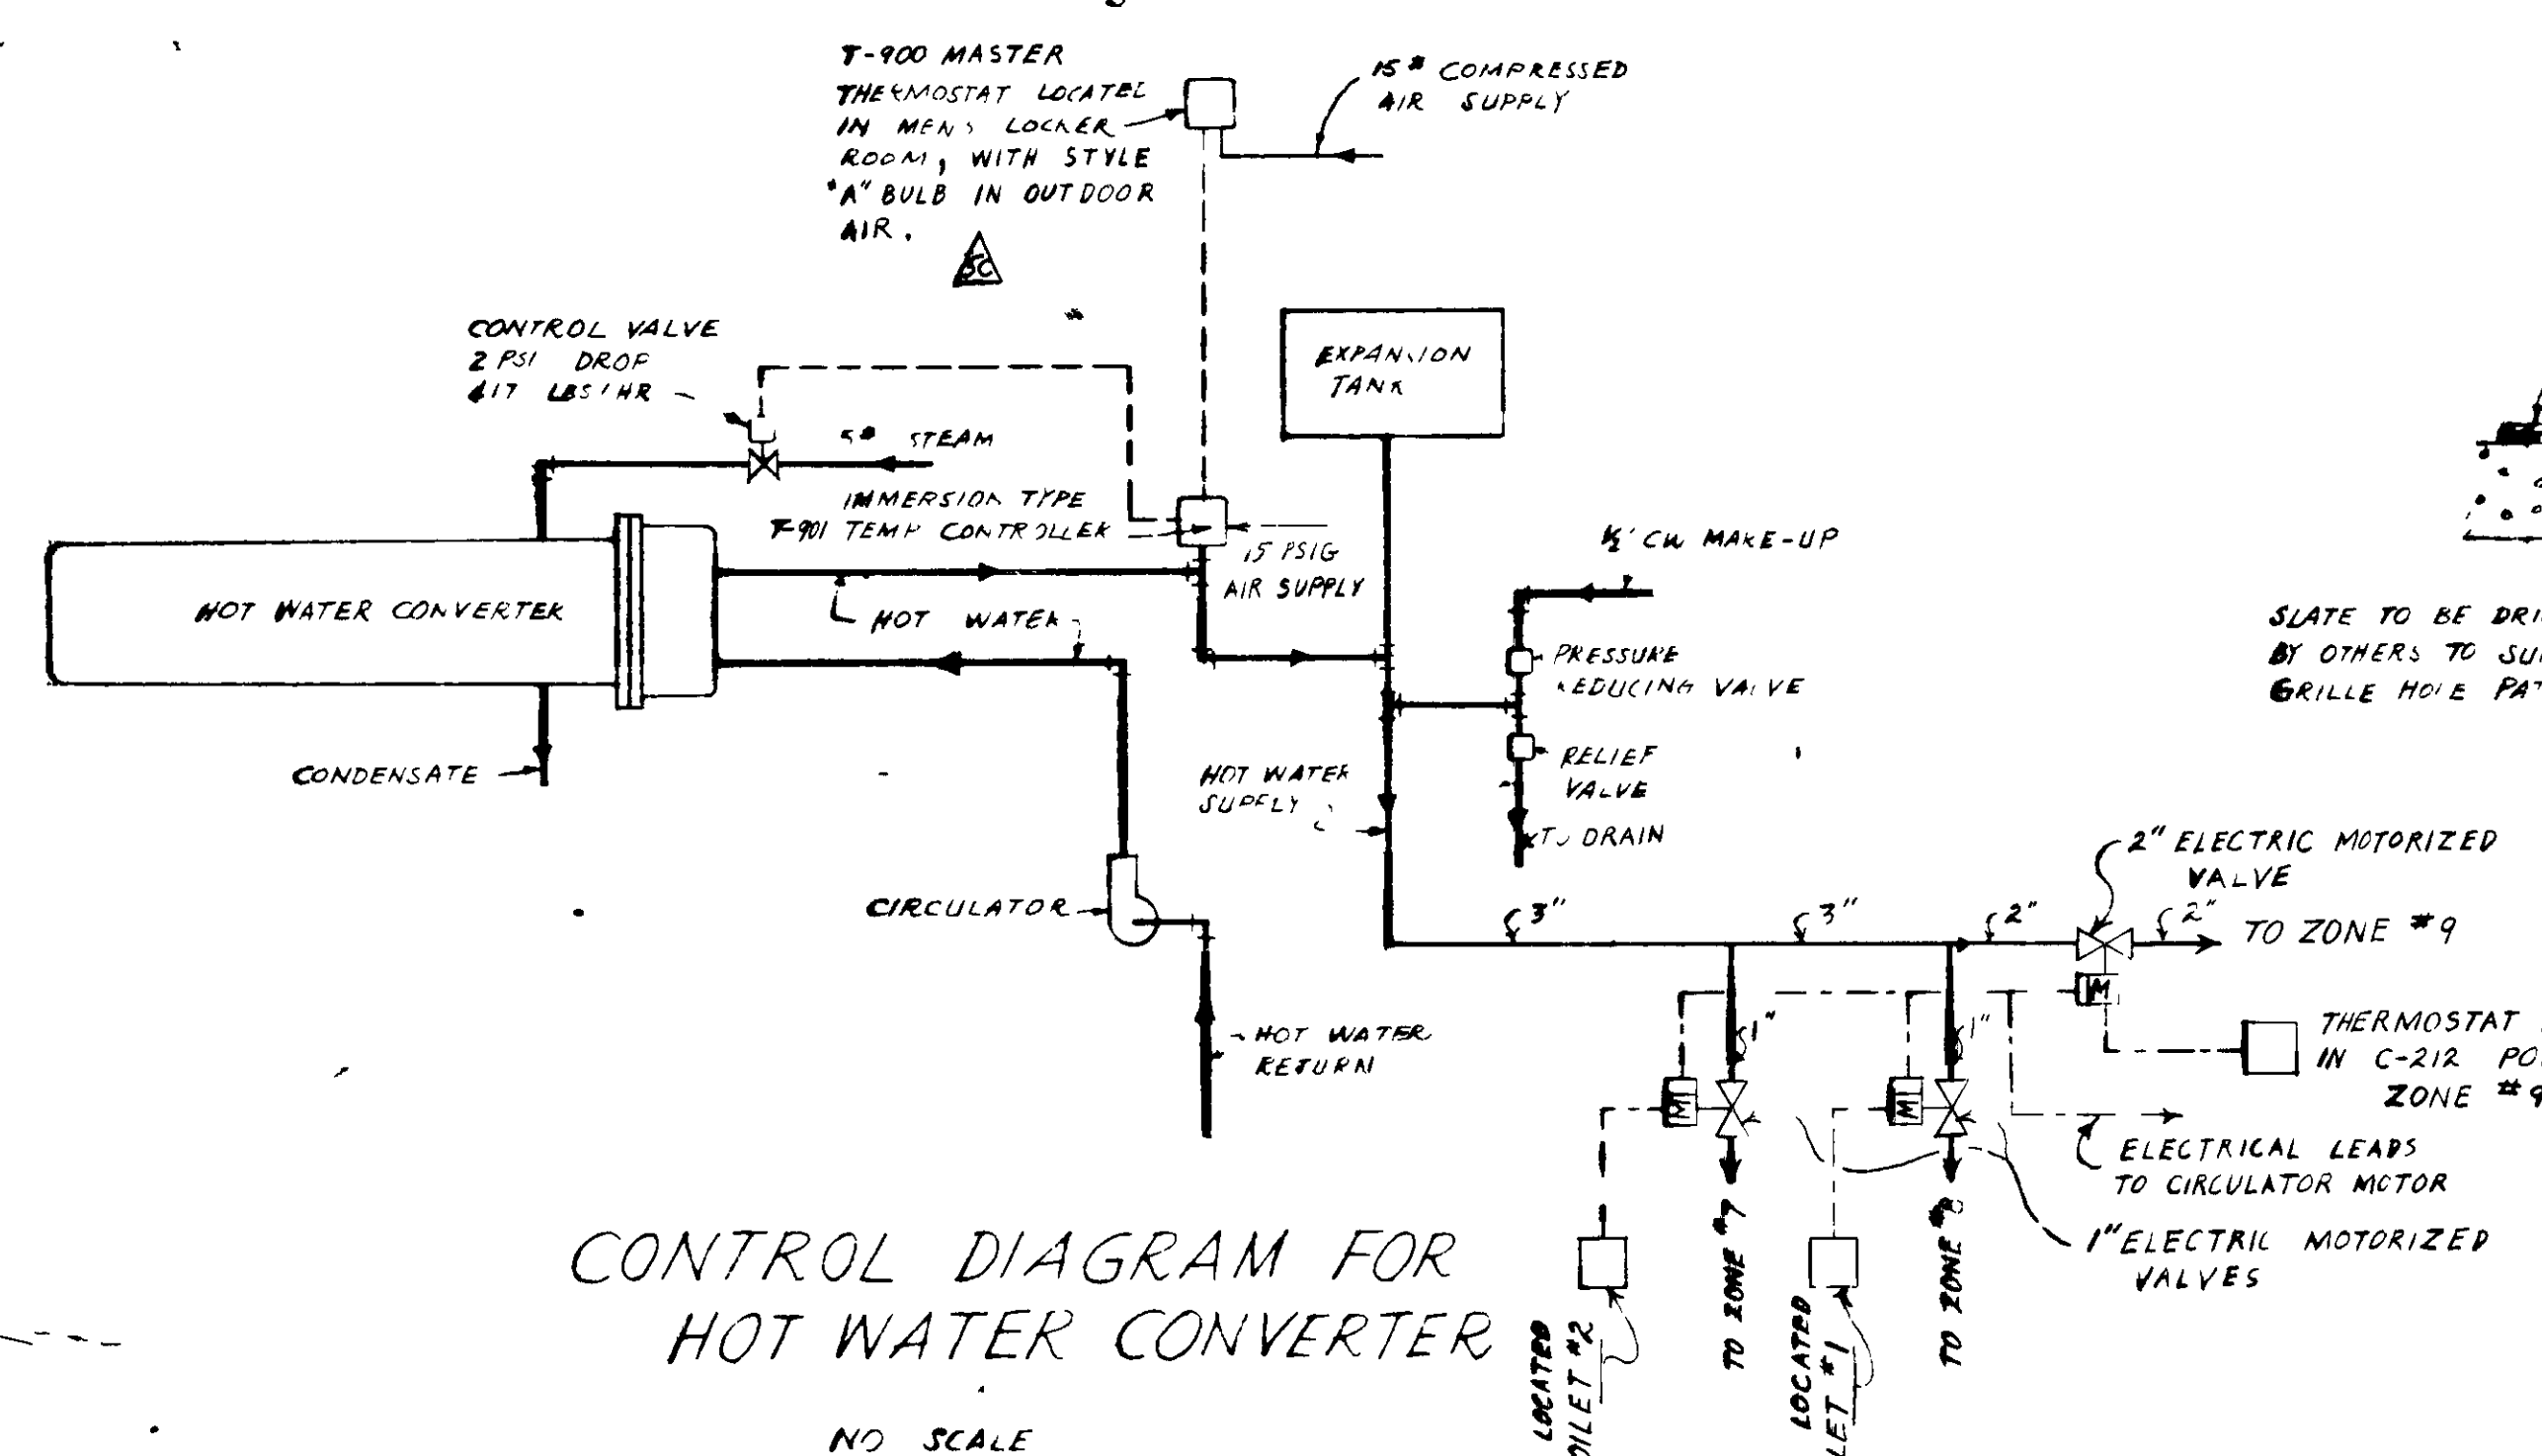

CONTROL DIAGRAM FOR HOT WATER CONVERTER
NO SCALE

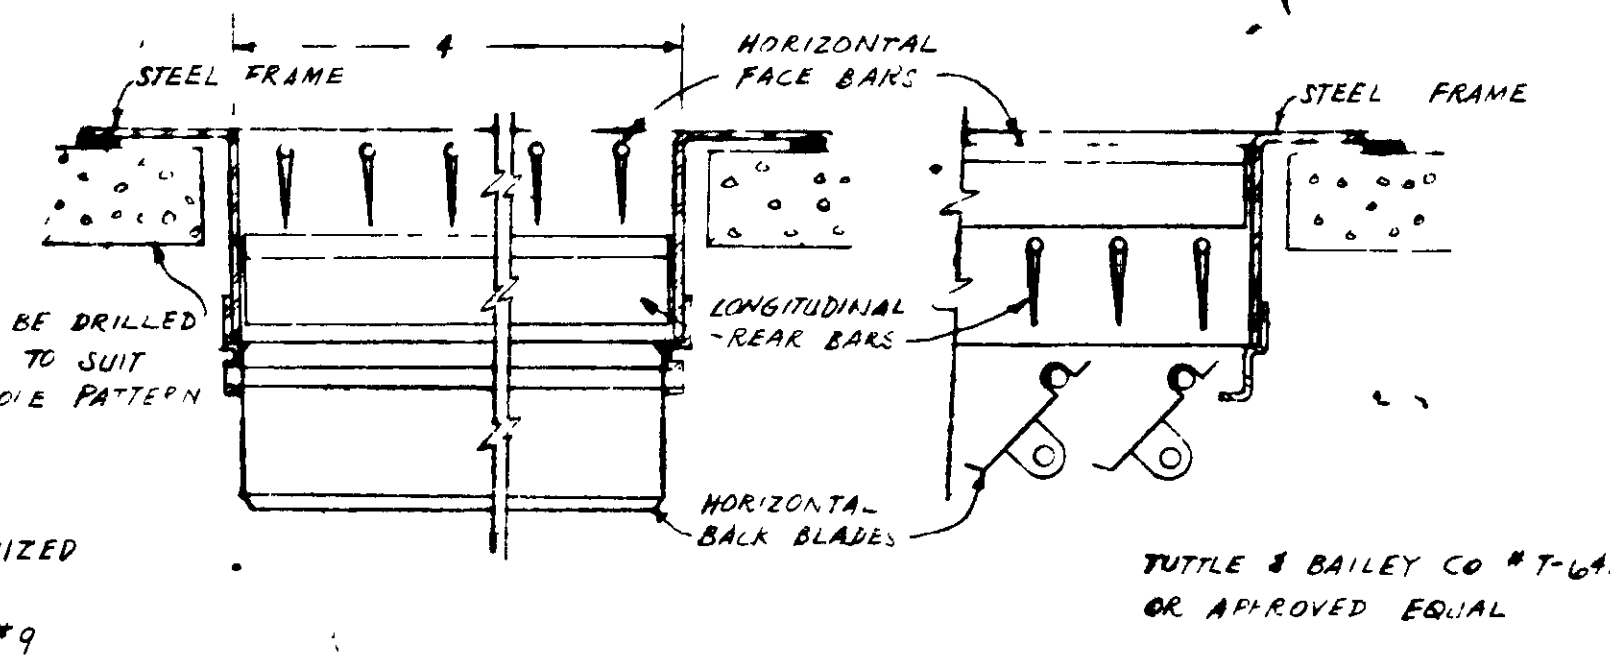

TYPICAL SUPPLY REGISTER DETAIL
NO SCALE

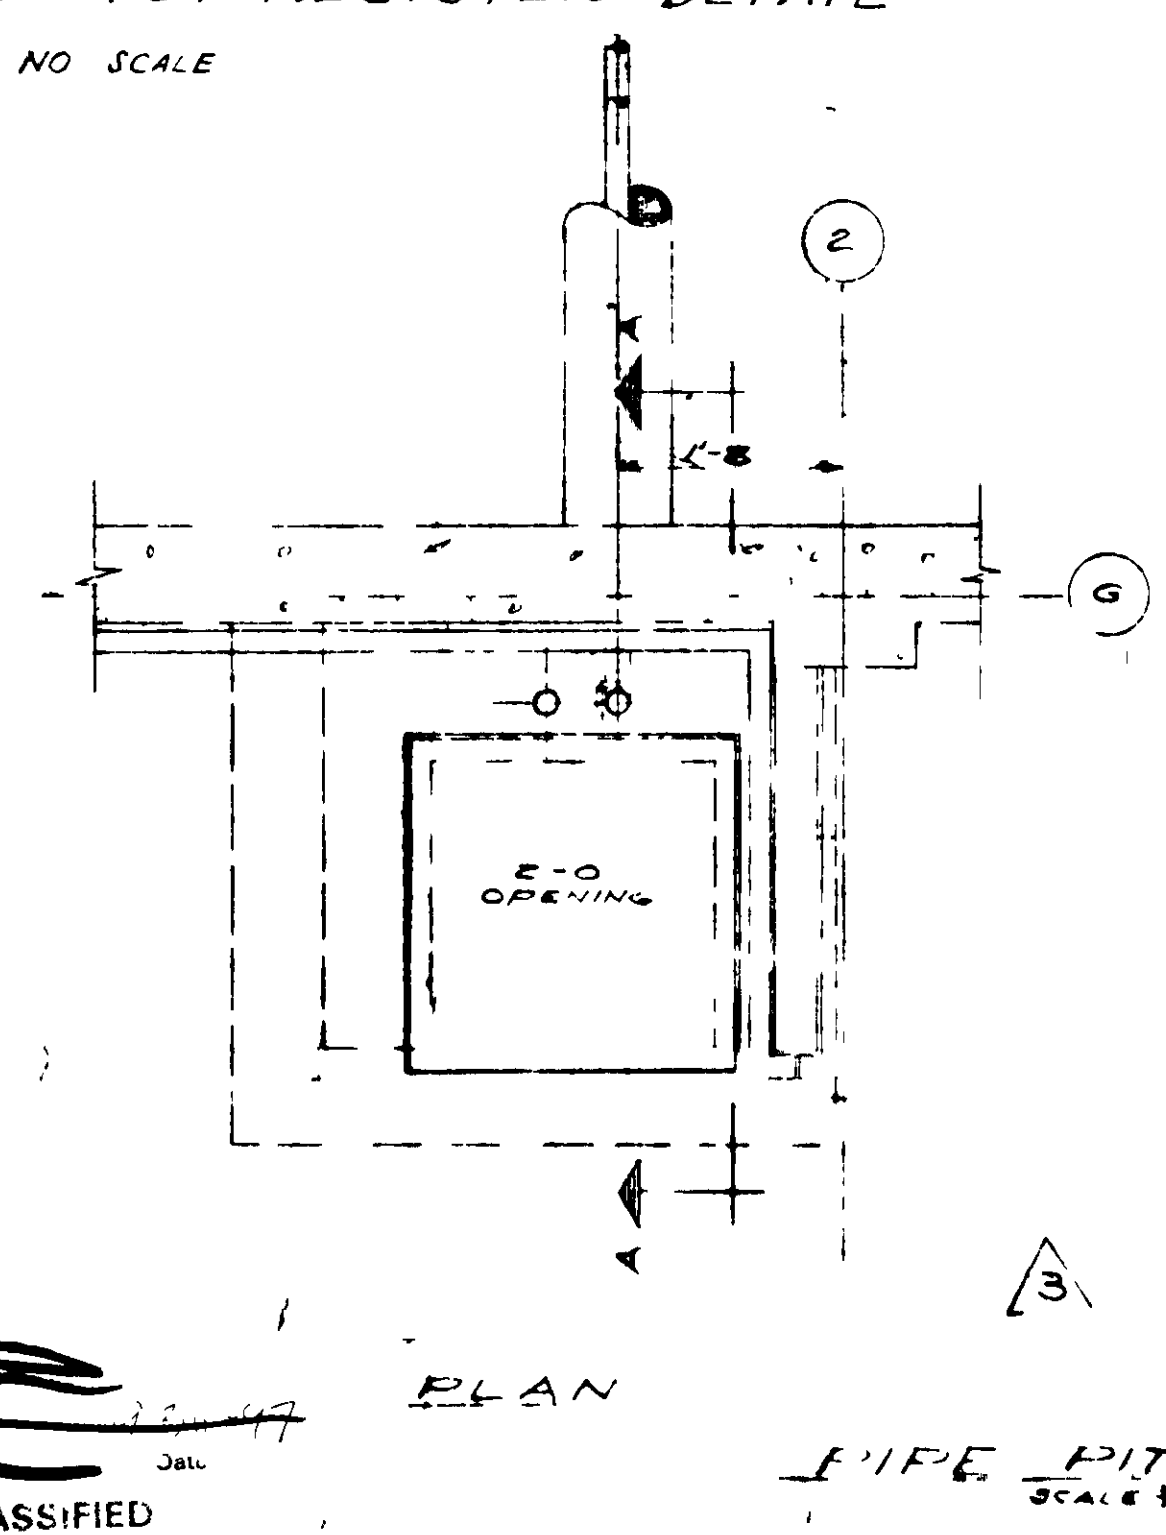

PIPE PIT DETAIL
SCALE 3/4\"/>

REV	DATE	DESCRIPTION
1	11/19/88	REVISED
2	11/22/88	REVISED
3	11/22/88	REVISED
4	11/22/88	REVISED
5	11/22/88	REVISED
6	11/22/88	REVISED
7	11/22/88	REVISED
8	11/22/88	REVISED
9	11/22/88	REVISED
10	11/22/88	REVISED

CLASSIFICATION: Unclassified
 AUTHORITY: Doc. No. 817197
 DATE: 11/22/88
 SIGNATURE: [Signature]
 TITLE: [Title]

REFERENCE DRAWINGS
 S460-BE-2-M REV. SC
 S460-BE-5-M REV. SC
 C4600-E-PI-PART1 REV. O

REVIEWED FOR CLASSIFICATION
 JBB 06/04/2014
 Initials Date
 UNCLASSIFIED

REV. NO.	DATE	REVISION	BY	APP. DATE
6C	12-28-84	AS BUILT		
5C	4-7-84	ADDED HEATING CONTROLS		
4	11-16-83	AS BUILT		
3	11-14-83	REVISION REQUEST #1778		
2	11-27-83	"B" CONSTRUCTION		11-20-83
1	11-30-83	APPROVAL		

UNITED STATES ATOMIC ENERGY COMMISSION		
SMITH, HINCHMAN & GRYLLS, INC ARCHITECTS & ENGINEERS DETROIT 26, MICHIGAN		
DRAWING TITLE AIR CONDITIONING CONTROL DIAGRAMS & DETAILS		
DRAWING APPROVED - DATE	DRAWING APPROVED - DATE	DRAWING APPROVED - DATE
[Signature]	RA WALKER 11-20-83	R J BROWN 11-20-83
DATE CHECKED	DATE CHECKED	DATE CHECKED
11-22-88	11-22-88	11-22-88
PROJECT	8768	
CAFETERIA		
C-101		
82-10-M		