

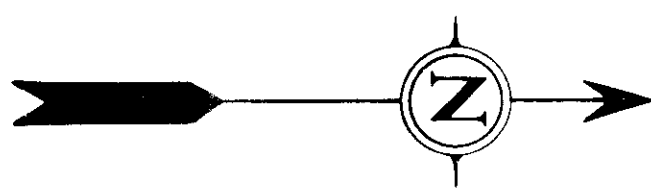


Unclassified

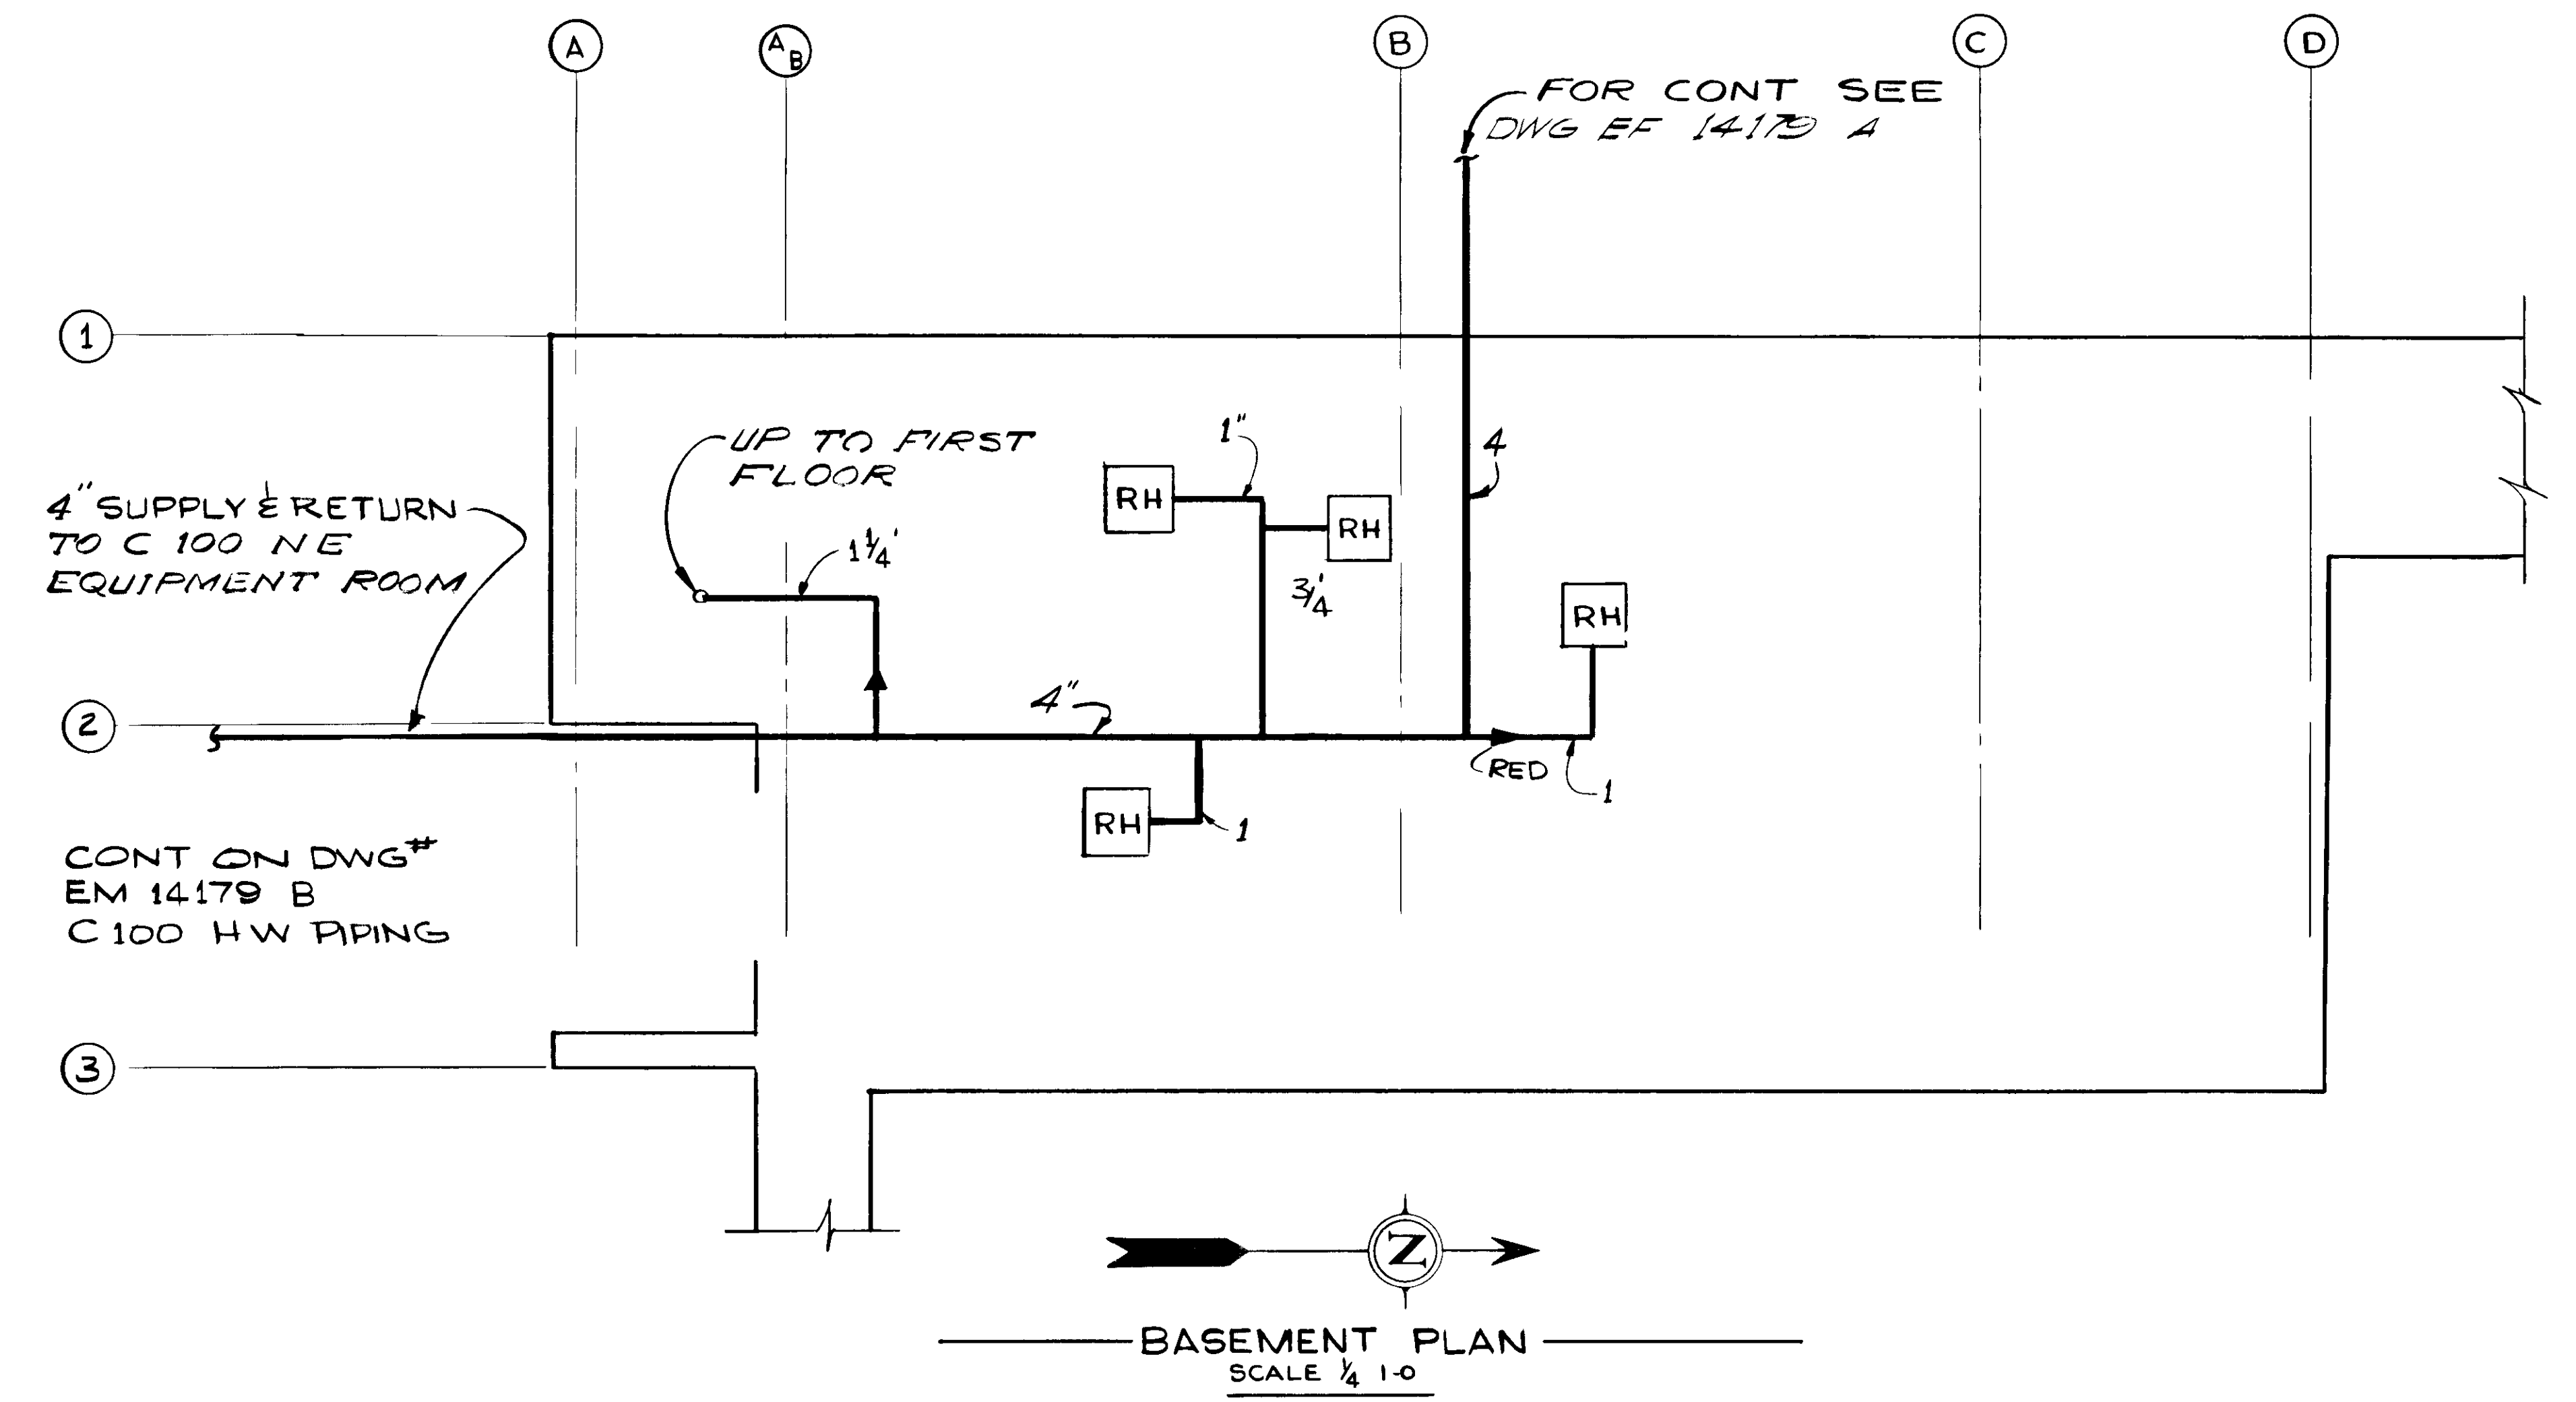

BASEMENT PLAN
SCALE 1/4" = 1'-0"

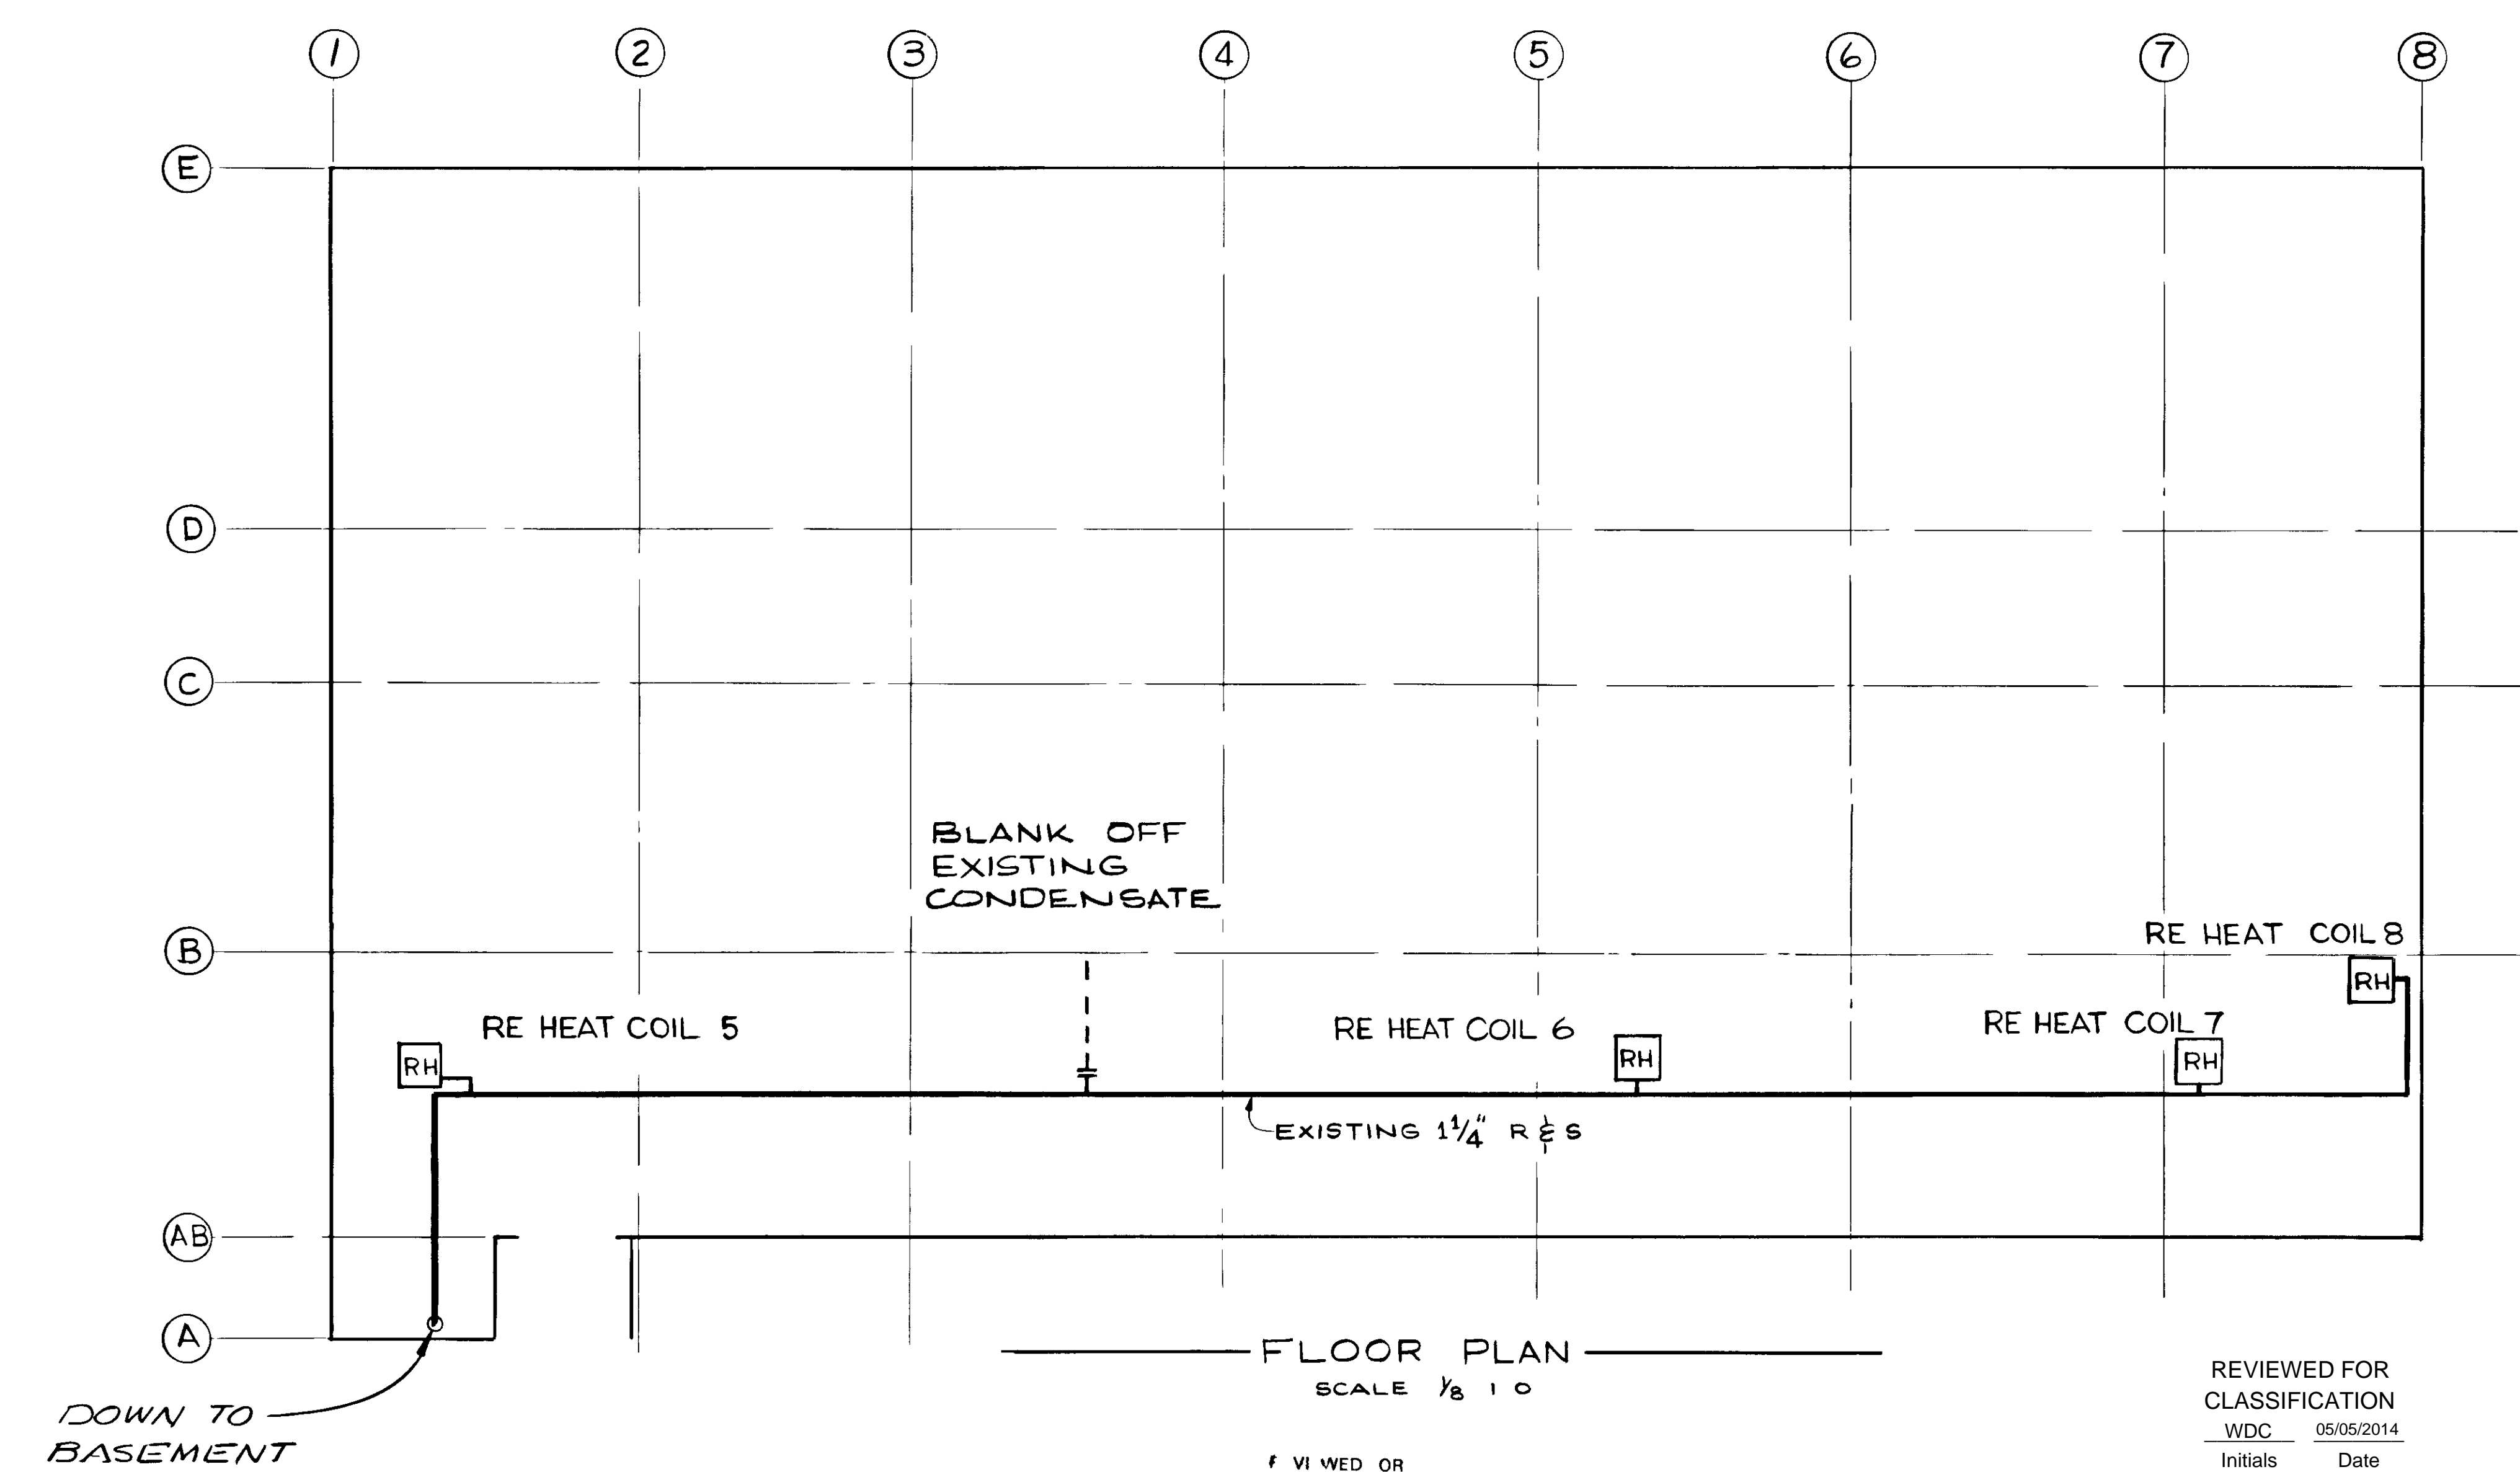

FLOOR PLAN
SCALE 1/8" = 1'-0"

- NOTE**
- 1 UTILIZE EXISTING LPS SUPPLY AND CONDENSATE RETURN LINES FOR HOT WATER SUPPLY & RETURN (RE HEAT COILS # 5, 6, 7, 8)
 - 2 LEAVE MPS SUPPLY TO AUTO CLAVE & BED PAN WASH
 - 3 FOR LEGEND & NOTES SEE DWG # EM 14179 B
 - 4 FOR TYP HOT WATER HOOKUP SEE DWG # EM 14179 B

BT Im lg v In
0001855 J

CONCEPTUAL PLAN

CONCEPTUAL APPROVED FOR ENERGY RESEARCH & DEVELOPMENT ADMINISTRATION APPROVED FOR UNION CARBIDE CORPORATION PADUCAH PLANT		ISSUED FOR REV CDR ORIGINAL ISSUE REVISIONS		SQUAD CHECK 14179		AS NOTED 1974 D.W. LWH 57 T. AN X. DI. AY. VA. Y. Y. DI. AY. VA. Y. Y. DI. AY. VA. Y. Y. DI. AY. VA. Y.		UNION CARBIDE CORPORATION NUCLEAR DIVISION - PADUCAH PLANT PROCESS WASTE HEAT UTILIZATION PLAN C 102 EM 14179 D REV B	
BY <i>L.O. B. L.W.</i> DATE <i>4/2/76</i>	BY <i>S. Bernick</i> DATE <i>3/24/76</i>	AS BUILT	REVISIONS	SQUAD CHECK	14179	AS NOTED	1974	D.W. LWH 57	UNION CARBIDE CORPORATION NUCLEAR DIVISION - PADUCAH PLANT PROCESS WASTE HEAT UTILIZATION PLAN C 102 EM 14179 D REV B