


### LEGEND

- ACCESS FLOORING, 2 FT SQ. LAY IN DIE CAST ALUMINUM PANELS
- EXISTING WALL PARTITIONS TO REMAIN IN PLACE
- EXISTING DOOR OPENINGS & MAKE-UP PARTITION SECTIONS SHALL BE REPLACED WITH FULL SECTIONS OF SOLID PANEL PARTITIONS
- EXISTING GLASS IN SOUTH PARTITION WALL SHALL REMAIN
- EXISTING PARTITION WALL PANELS TO BE REMOVED
- EXISTING CEILING SYSTEM TO BE REMOVED
- NEW 2' X 4' SUBSPUNDED ACOUSTICAL CEILING SYSTEM SHALL BE INSTALLED ACCORDING TO CEILING PLAN SHOWN ON ELECTRICAL DRAWING
- PERFORATED FLOOR PANELS
- SOLID FLOOR PANELS

## DETAILS & SECTIONS OF ACCESS FLOOR SYSTEM

NOT TO SCALE

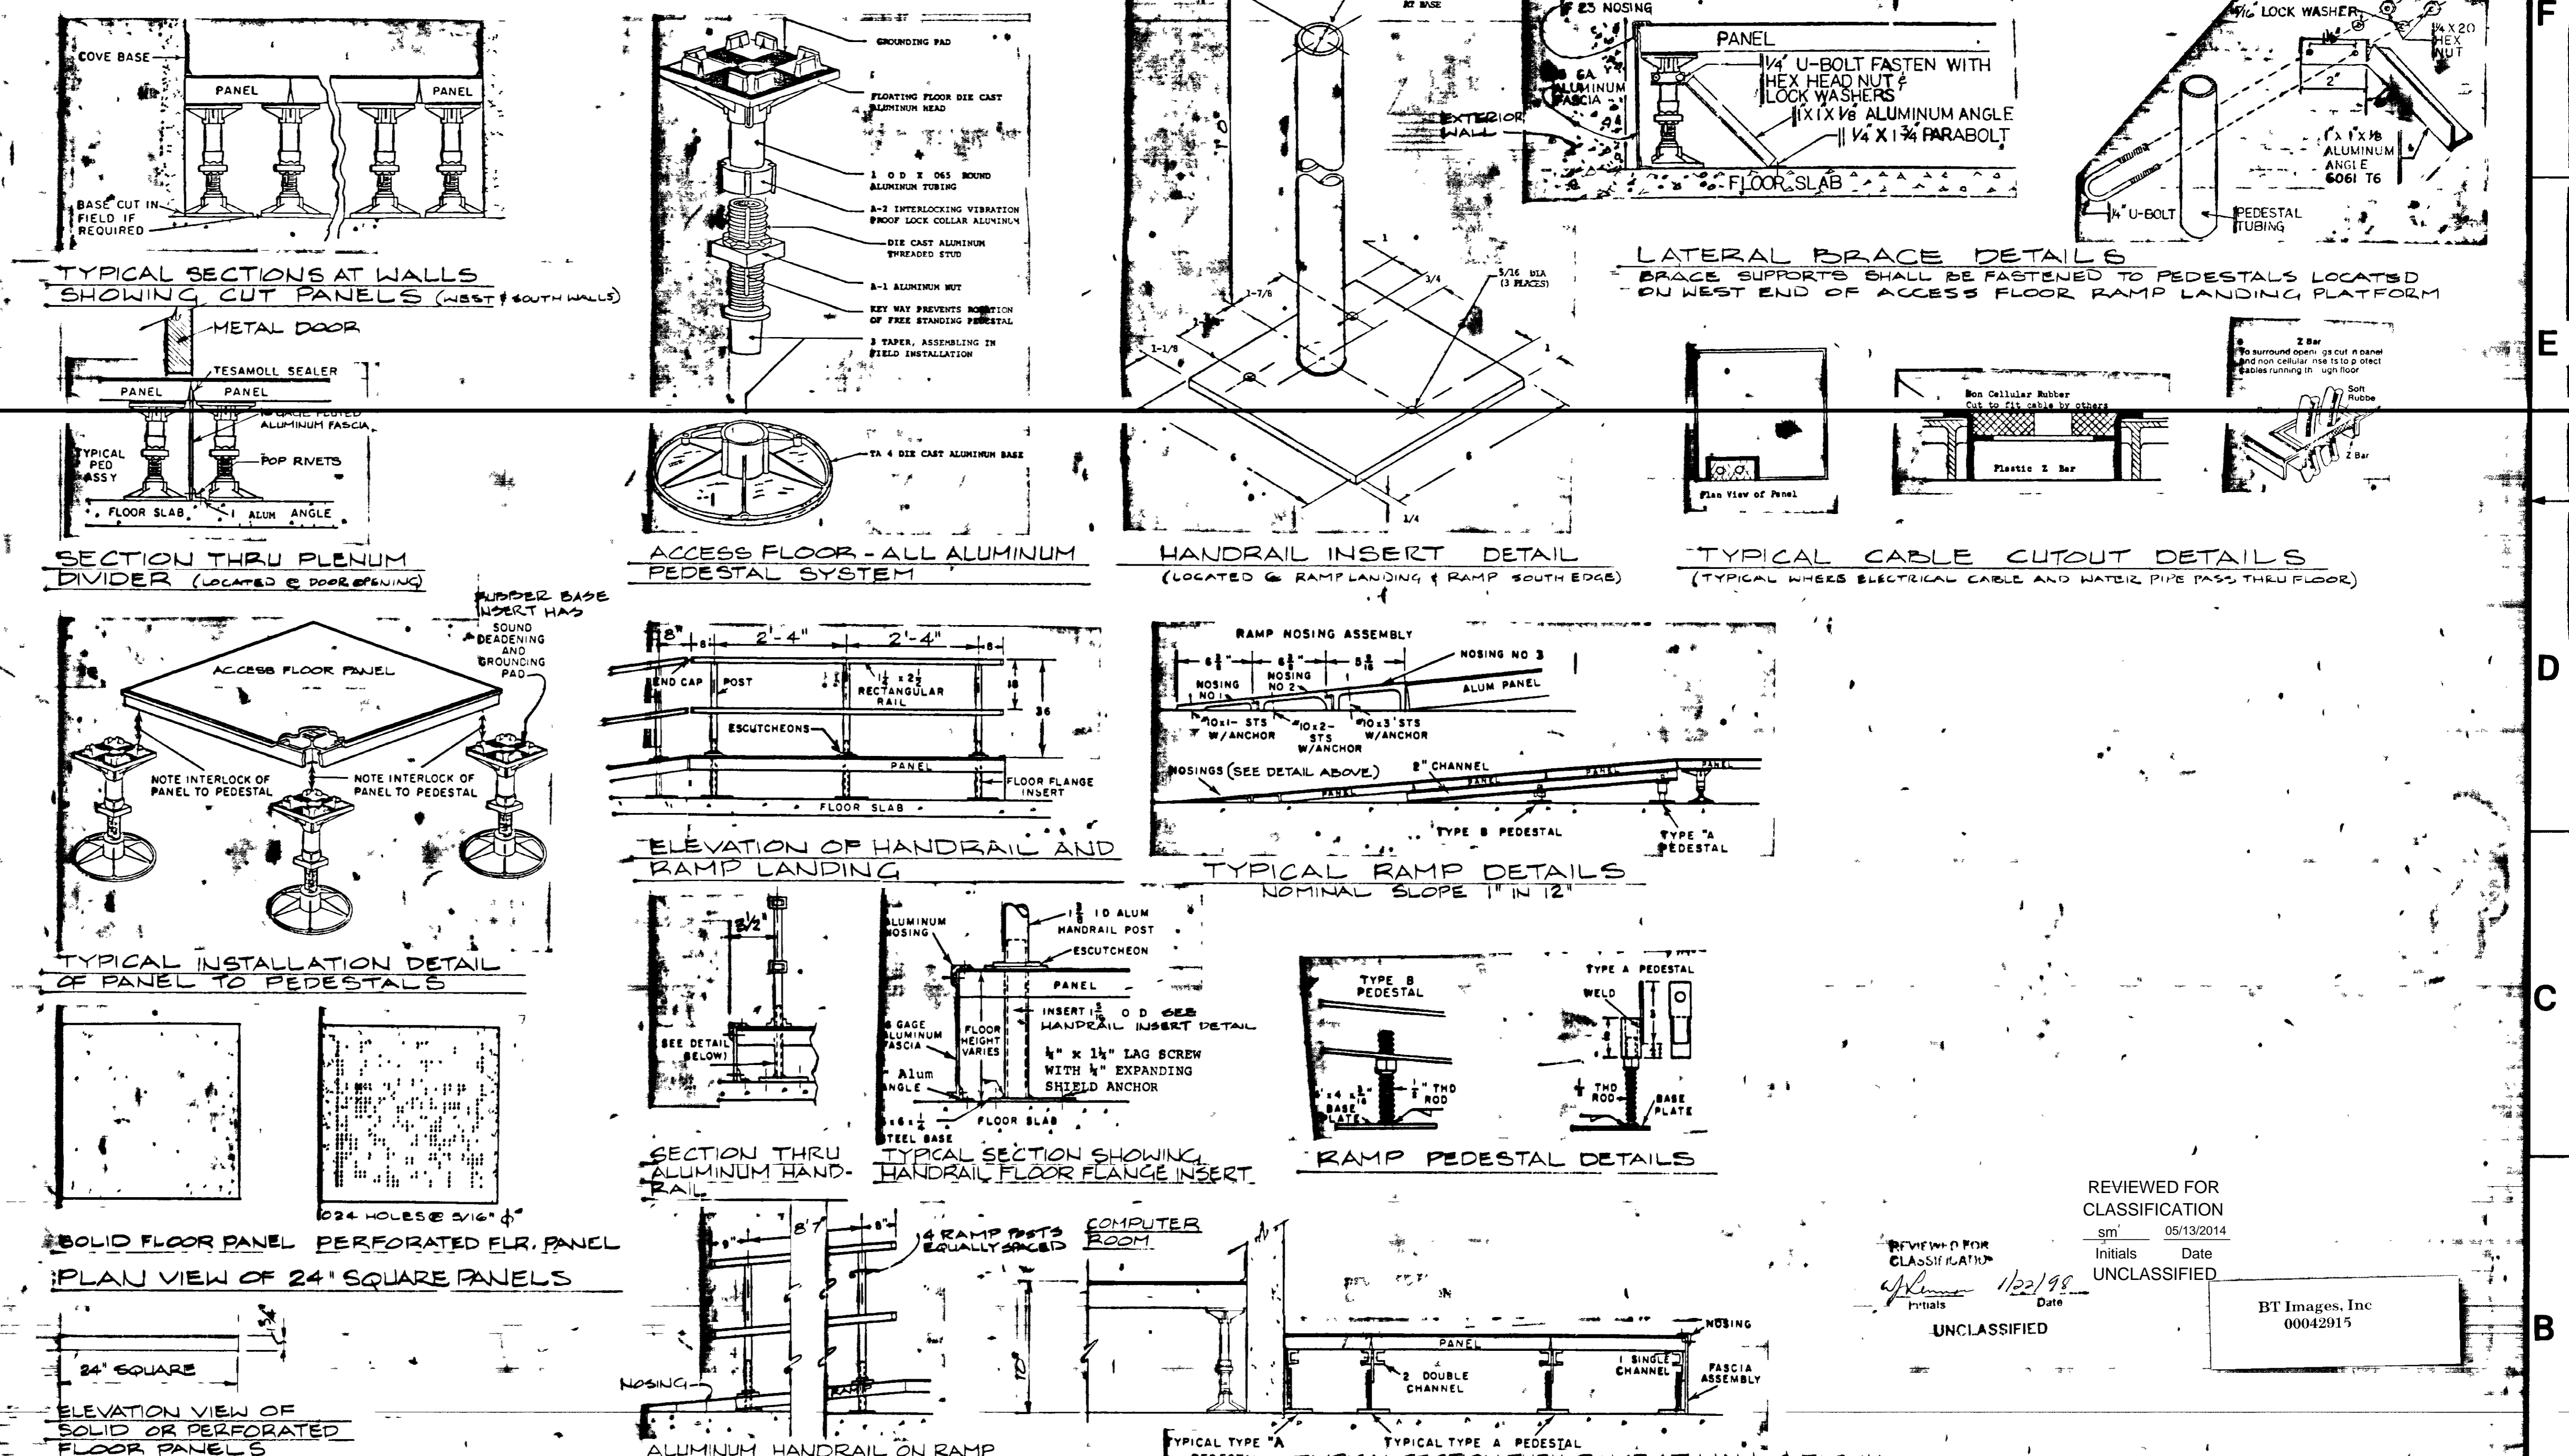

FLOOR PLAN OF COMPUTER ROOM, RAMP LANDING AND RAMP SCALE: 1/4" = 1'-0"

ROOM NUMBER	FLR FINISH	WALL BASE	WALLS NORTH/EAST/SOUTH/WEST	CEILING HEIGHT	REMARKS
100	RAISED VINYL	LATEX ENAMEL PAINT	LAY-IN 8' 0"	NEW CEILING	
200	RAISED	N/A	N/A	N/A	ONLY RAMP

- NOTE:**
- FOR REFLECTED CEILING SYSTEM PLAN, SEE LIGHTING PLAN DRAWING ESE 16061 A.
  - ACCESS FLOOR SYSTEM & ALL RELATED COMPONENT PARTS AS SHOWN ON THIS DRAWING SHALL BE MANUFACTURED BY THE ACCESS FLOOR COMPANY.
  - REPLACEMENT PARTITION WALL PANELS SHALL BE FURNISHED BY CONTRACTOR.

REVIEWED FOR CLASSIFICATION  
 Initials Date  
 UNCLASSIFIED  
 BT Images, Inc. 00042915

NO REPRESENTATION OR WARRANTY EXPRESSED OR IMPLIED, IS MADE THAT THE USE OR DISCLOSURE OF ANY INFORMATION, APPARATUS, METHOD OR PROCESS DISCLOSED IN THESE DRAWINGS MAY NOT INFRINGE PRIVATE RIGHTS OF OTHERS. NO LIABILITY IS ASSUMED WITH RESPECT TO THE USE OF OR FOR DAMAGES RESULTING FROM THE USE OF ANY INFORMATION, APPARATUS, METHOD OR PROCESS DISCLOSED IN THESE DRAWINGS. THE DRAWINGS ARE BEING MADE AVAILABLE FOR INFORMATION TO BIDDER AND ARE NOT TO BE USED FOR OTHER PURPOSES, AND ARE TO BE RETURNED UPON REQUEST OF THE FORWARDING CONTRACTOR.		SECTION NUMBER OR DETAIL LETTER		SHEET WHERE DETAIL OR SECTION IS SHOWN		SECTION & DETAIL LEGEND		BY DATE SECT REV		REVISION OR ISSUE PURPOSE		BY CHK RED SECT DEPT DATE PE REG DATE UCCND DATE DOE DATE GE CA EC EE MD IE MA CP SE CE		TOLERANCES UNLESS OTHERWISE SPECIFIED		DESIGNER/ENGINEER		UNION CARBIDE CORPORATION - NUCLEAR DIVISION		SUPPLEMENTAL AIR CONDITIONING, COMPUTER ROOM, C-100 FLOOR PLAN AND DETAILS		SCALE AS SHOWN		DATE	
		1		11/21/83		RLE		1		CHANGED CEILING HGT.		RBP		1/83		JLS		UNION CARBIDE CORPORATION - NUCLEAR DIVISION		SUPPLEMENTAL AIR CONDITIONING, COMPUTER ROOM, C-100 FLOOR PLAN AND DETAILS		SCALE AS SHOWN		DATE	
		2						2		C.F.C.		JLS		1/83		JLS		UNION CARBIDE CORPORATION - NUCLEAR DIVISION		SUPPLEMENTAL AIR CONDITIONING, COMPUTER ROOM, C-100 FLOOR PLAN AND DETAILS		SCALE AS SHOWN		DATE	
		3						3		APPROVAL TITLE II		JLS		1/83		JLS		UNION CARBIDE CORPORATION - NUCLEAR DIVISION		SUPPLEMENTAL AIR CONDITIONING, COMPUTER ROOM, C-100 FLOOR PLAN AND DETAILS		SCALE AS SHOWN		DATE	