


SOUTHEAST EQUIPMENT ROOM PLAN
SCALE 1/4" = 1'-0"

Unclassified

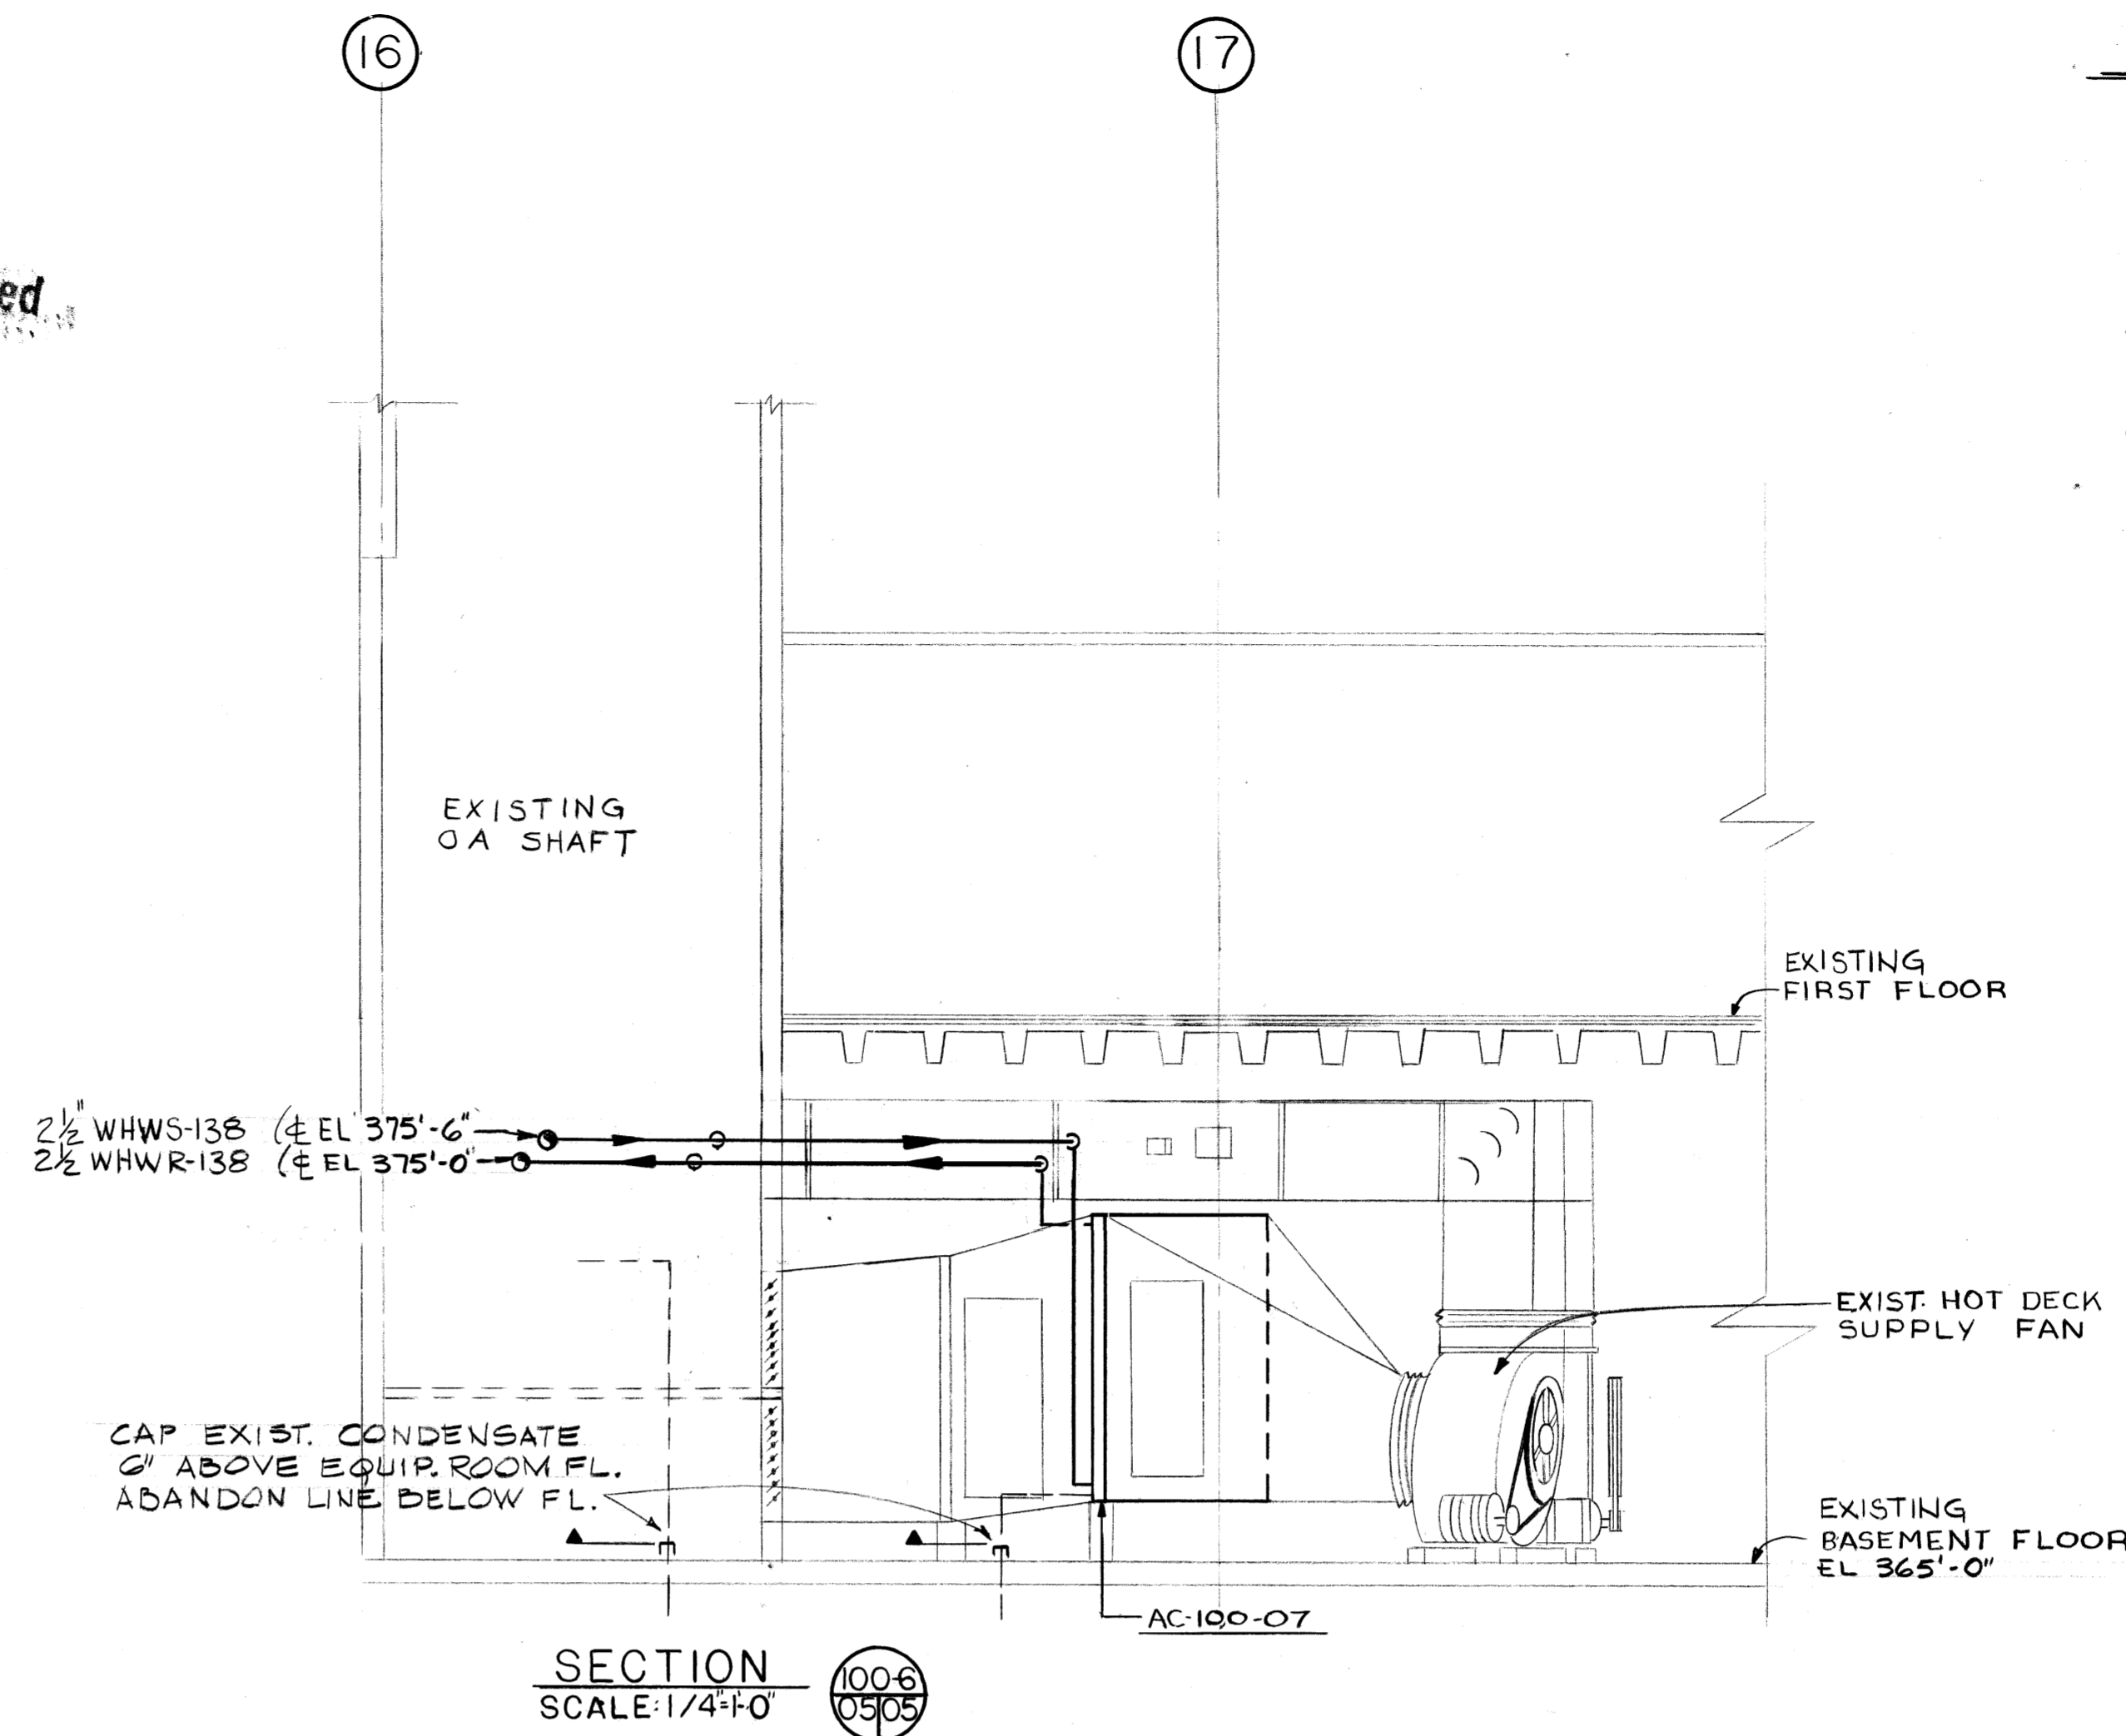

 
SECTION
SCALE 1/4" = 1'-0"

NOTES

1. FOR GENERAL NOTES & LEGEND SEE DWG. 01
2. REFER TO DWG. 06 FOR HOT WATER HEATING COIL & CONTROL VALVE SCHEDULES.-BLDG. C-100
3. REFER TO ARCHITECTURAL DWGS. FOR WALL PENETRATION DETAILS
4. REFER TO DWG. 03 FOR TYPICAL CONTROL DIAGRAM BLDG. C-100
5. REFERENCE DWG. B1-6-M JOB NO. 876 B


FOR INFORMATION ONLY

GRAPHIC SCALES




REVIEWED FOR CLASSIFICATION
Initials: *[Signature]* Date: 1/24/88
UNCLASSIFIED

REVIEWED FOR CLASSIFICATION
DE: 06/13/2014
Initials: Date:
UNCLASSIFIED

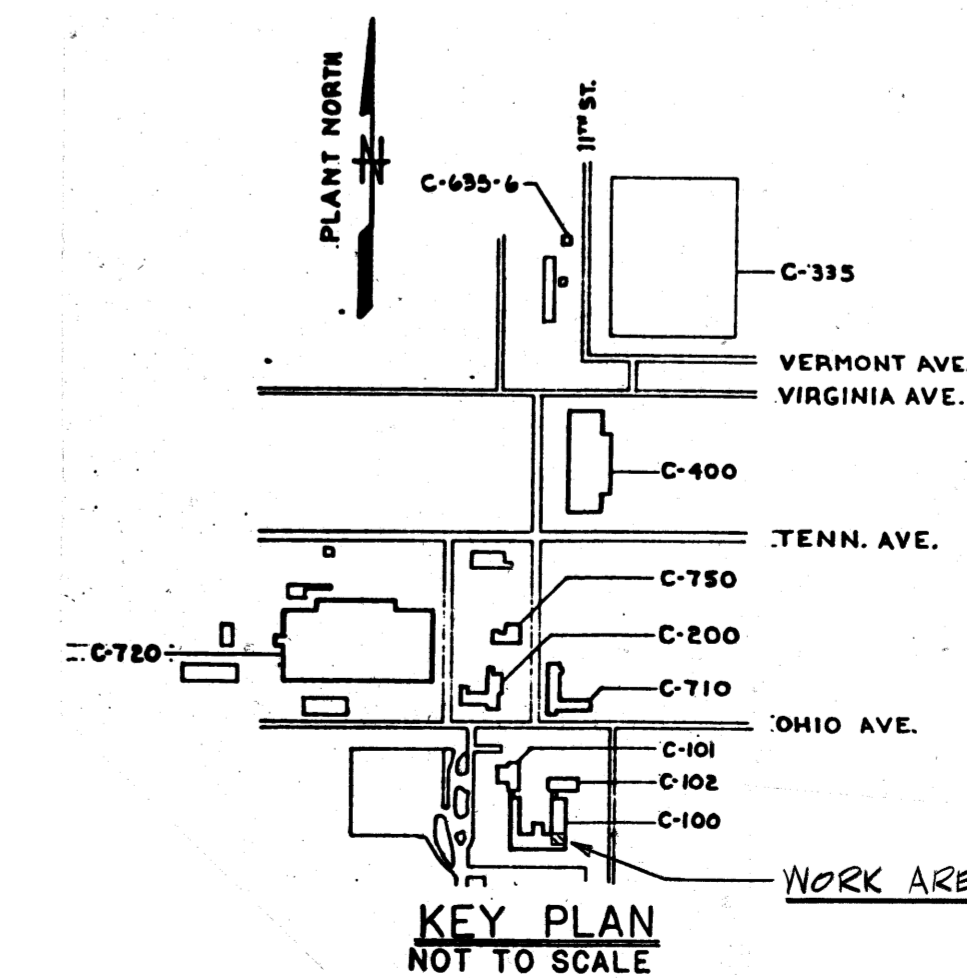


KEY PLAN
NOT TO SCALE

PIPELINE IDENTIFICATION	SPEC. NO. (MATERIAL)
SIZE: 2" WHWS-138	
SERVICE:	

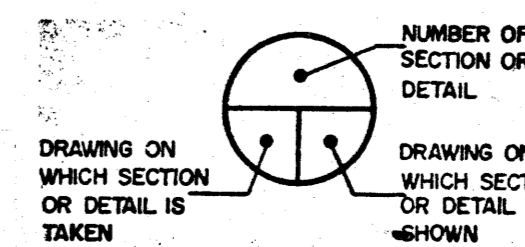

SECTION & DETAIL KEY

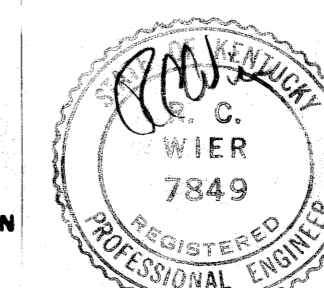

BT Images, Inc. 00021573			
1c AS BUILT	12/9/81	2464	
0 CERTIFIED FOR CONSTRUCTION	1/28/88	4108	07-83
REV. NO.	ISSUE PURPOSE (PASC-6279)	DATE	APPROVAL
		3-27-79	8-27-79
		DATE	APPROVAL

UNITED STATES DEPARTMENT OF ENERGY			
A. M. KINNEY, INC.			
DOE CONTRACT NO. EW78-C-55-5886 CINCINNATI, OHIO A/E PROJECT NO. 02434			
HVAC BUILDING C-100 SOUTHEAST EQUIPMENT ROOM PLAN			
SUBMITTED - DATE	APPROVAL RECOMMENDED - DATE	DRAWING APPROVED - DATE	
12/9/81	2-27-79	3/27/79	
DRAWN	DATE	CHECKED	DATE
C.W. WIER	5-17-78	JAM	2-16-79
ARCHITECT-ENGINEER	OPERATOR	DOE-ENGINEER	
1	48	50	30
PLANT	CHIEF	DATE	SCALE
PADUCAH	2/16/79	1/4" = 1'-0"	
PROJECT	DRAWING NUMBER	REV. NO.	
PROCESS WASTE HEAT UTILIZATION	H5E-14951-0005	1c	

MICROFILMED